

# Drawing List

Drawing List			
Sheet No	Sheet Name	Drawn By	Designed By
100	SITE PLAN	B.LAW	C.GONZALEZ
101	ROOF PLAN	B.LAW	C.GONZALEZ
102	VERGE MANAGMENT PLAN	B.LAW	C.GONZALEZ
103	SOIL EROSION CONTROL PLAN	B.LAW	C.GONZALEZ
104	TREE MANAGEMENT PLAN	B.LAW	C.GONZALEZ
105	CARPARK LAYOUT	C.GONZALEZ	C.GONZALEZ
106	RETAINING WALLS	B.LAW	C.GONZALEZ
107	LANDSCAPE PLAN	C.GONZALEZ	C.GONZALEZ
108	EXTERNAL LIGHTING PLAN	B.LAW	B.LAW
109	EMERGENCY LIGHTING PLAN	B.LAW	B.LAW
110	INTERNAL LIGHTING PLAN	B.LAW	B.LAW
111	POWER PLAN	B.LAW	B.LAW
200	FLOOR PLAN	C.GONZALEZ	C.GONZALEZ
201	PUBLIC NOTIFICATION PLAN	B.LAW	C.GONZALEZ
202	INDICATIVE FIRE PREPARATION PLAN	B.LAW	B.LAW
300	ELEVATIONS	C.GONZALEZ	C.GONZALEZ
301	ELEVATIONS	C.GONZALEZ	C.GONZALEZ
302	SECTIONS	B.LAW	C.GONZALEZ
303	SECTIONS	B.LAW	C.GONZALEZ
400	ALTAR DETAILS	C.GONZALEZ	C.GONZALEZ

# Project Details

Project Name: PROPOSED BUDDHIST TEMPLE

Client Name: KHEMARARANGSI BUDDHIST  
TEMPLE OF ACT Inc

Project Address: BLOCK 28 SECTION 43 SCULLIN


Project No: 4017-B

Print Date: 14.08.15



Building Design, Drafting, Architectural  
illustrations, BASIX & Energy Ratings  
ABN: 85441177997

cristian@studio56.com.au  
0403 363 841  
renee@studio56.com.au  
0402 988 379

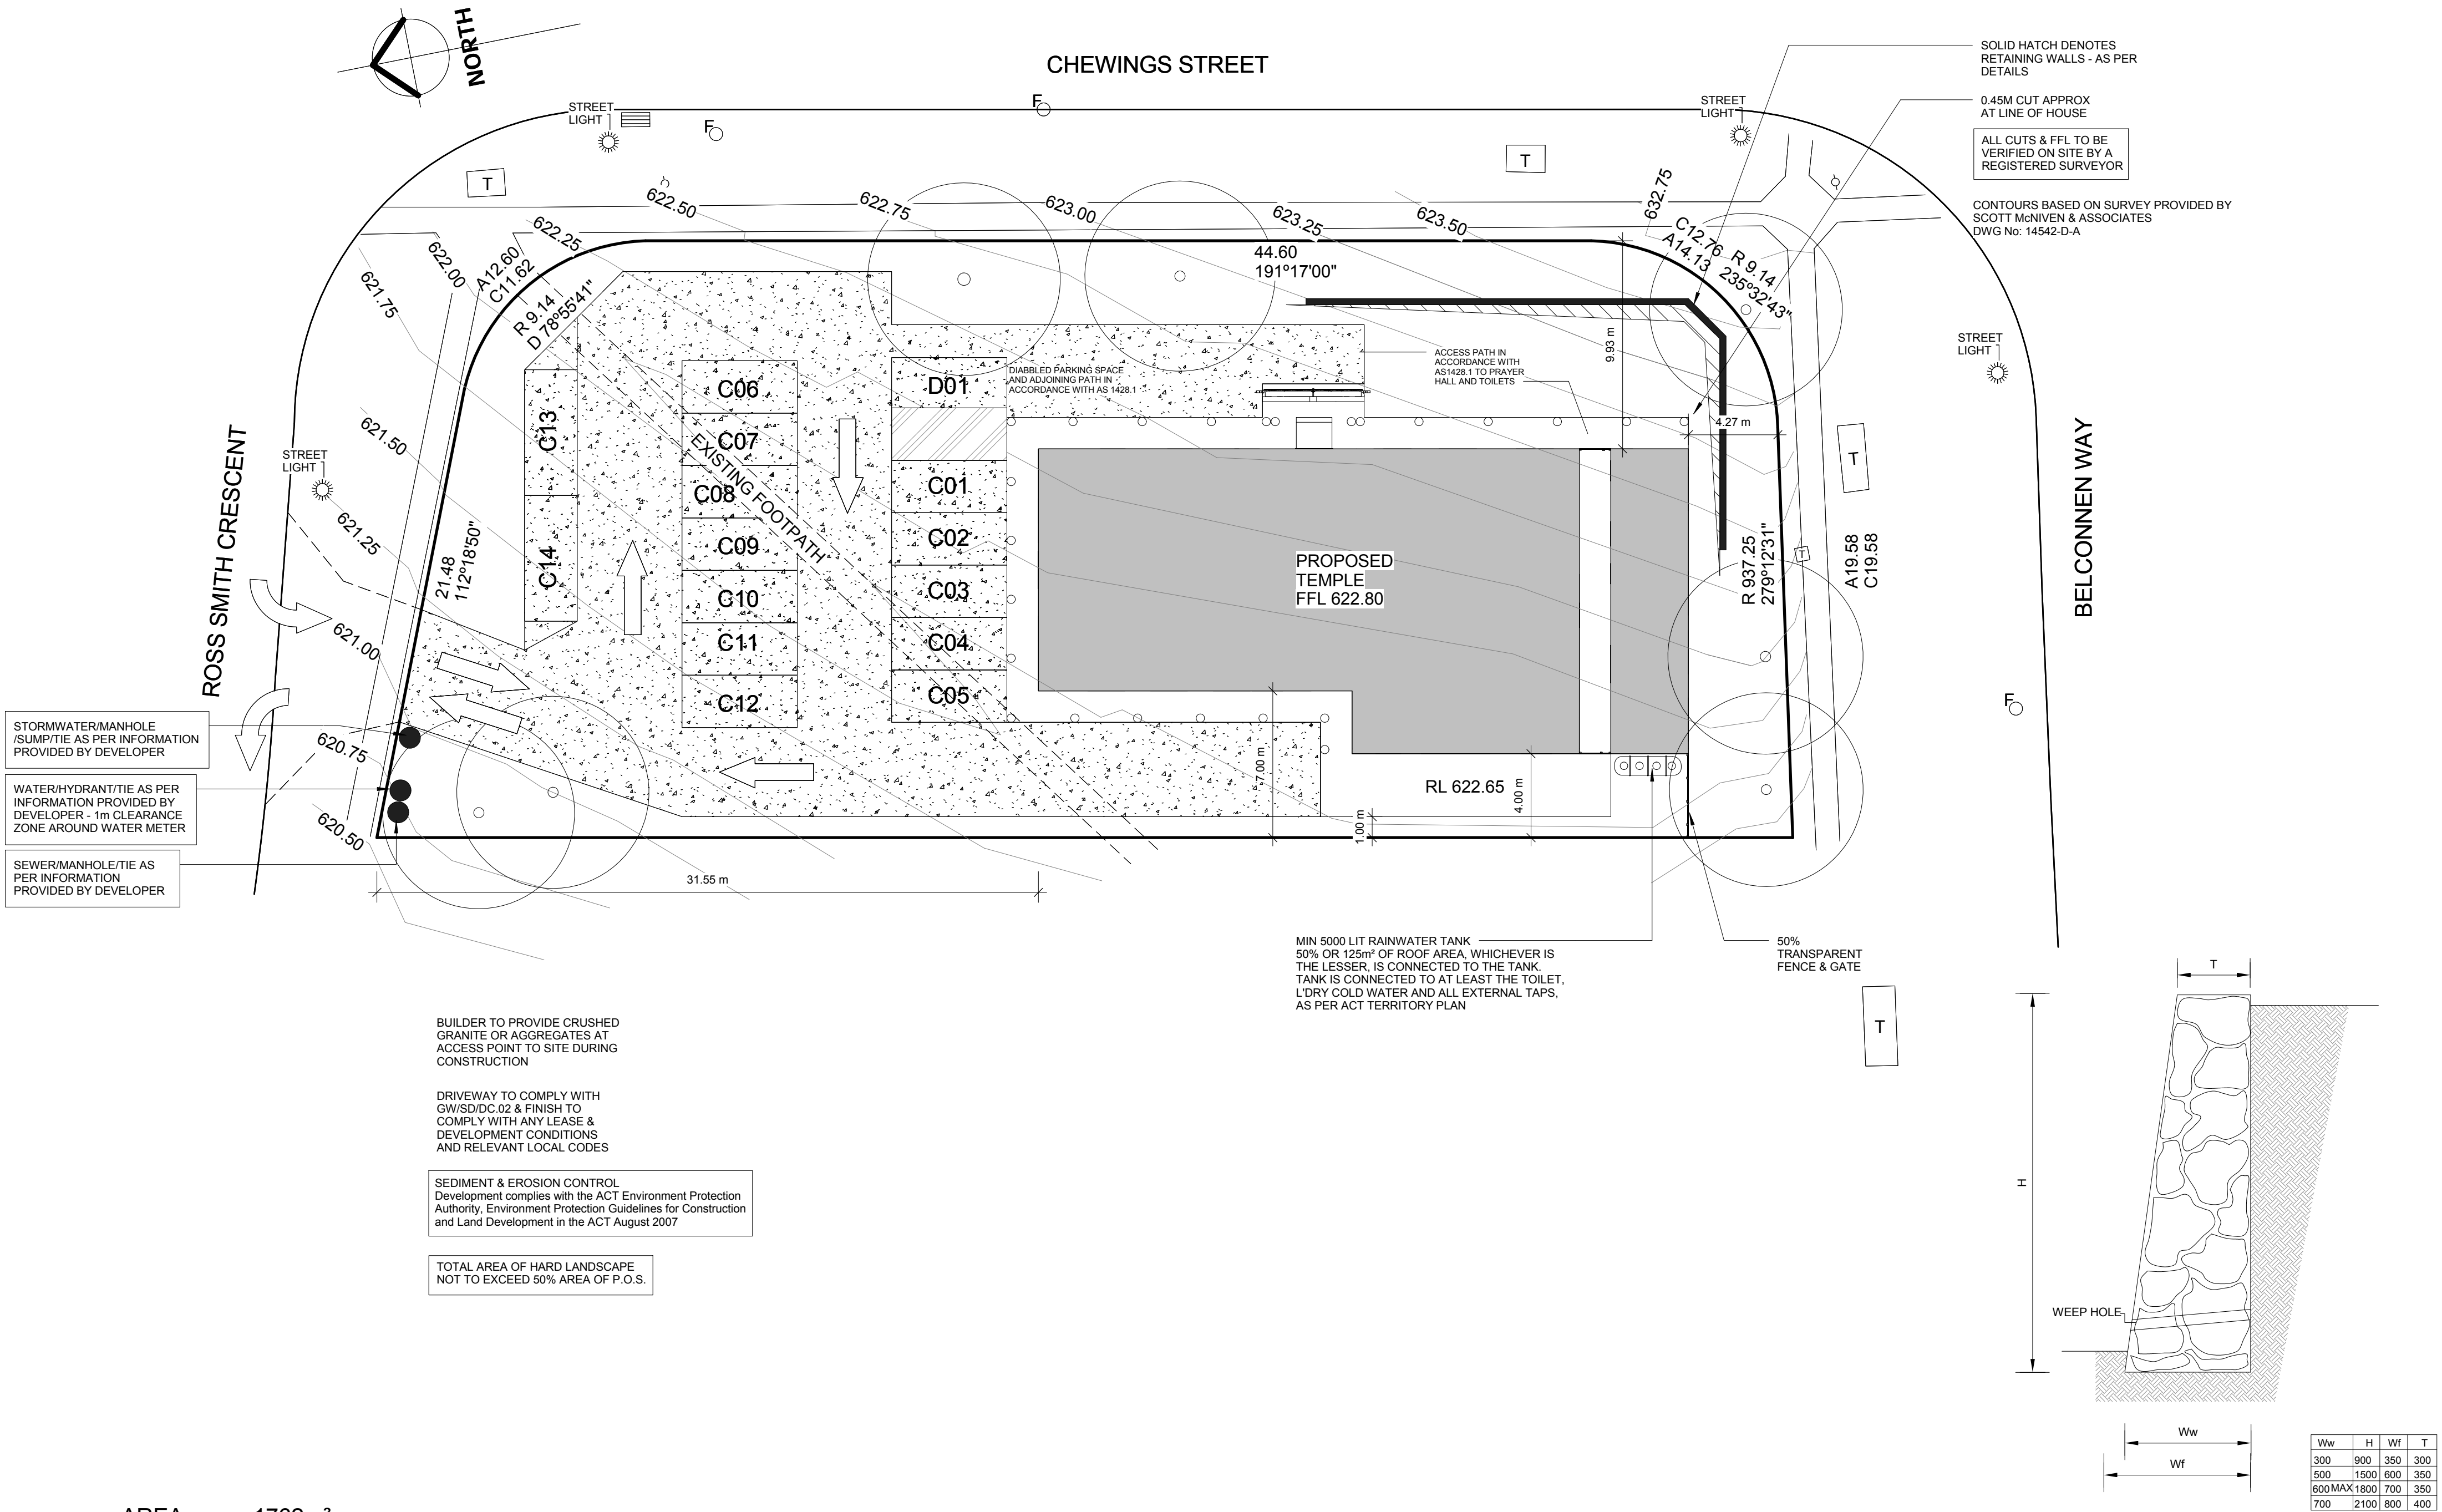

AREA: 1762m²

ROCK RETAINING WALL



Building Design, Drafting, Architectural illustrations, BASIX & Energy Ratings  
ABN: 85441177997  
cristian@studio56.com.au  
0403 363 841  
renee@studio56.com.au  
0402 988 379


© COPYRIGHT Studio56  
THIS PLAN REMAINS THE PROPERTY OF Studio56 & MAY NOT BE COPIED IN WHOLE OR IN PART WITHOUT WRITTEN PERMISSION, FAILURE TO DO SO WILL RESULT IN LEGAL ACTION

Client Name: KHEMARARANGSI BUDDHIST TEMPLE OF ACT Inc  
Project : PROPOSED BUDDHIST TEMPLE  
Address: BLOCK 28 SECTION 43 SCULLIN


Sheet Name SITE PLAN

Project number	4017-B	DA: 201527708	Scale	Sheet Number	Rev No
Date	12.08.2015		1 : 200	100	
Drawn by	B.LAW	Design by	C.GONZALEZ		





Ww	H	Wf	T
300	900	350	300
500	1500	600	350
600MAX	1800	700	350
700	2100	800	400

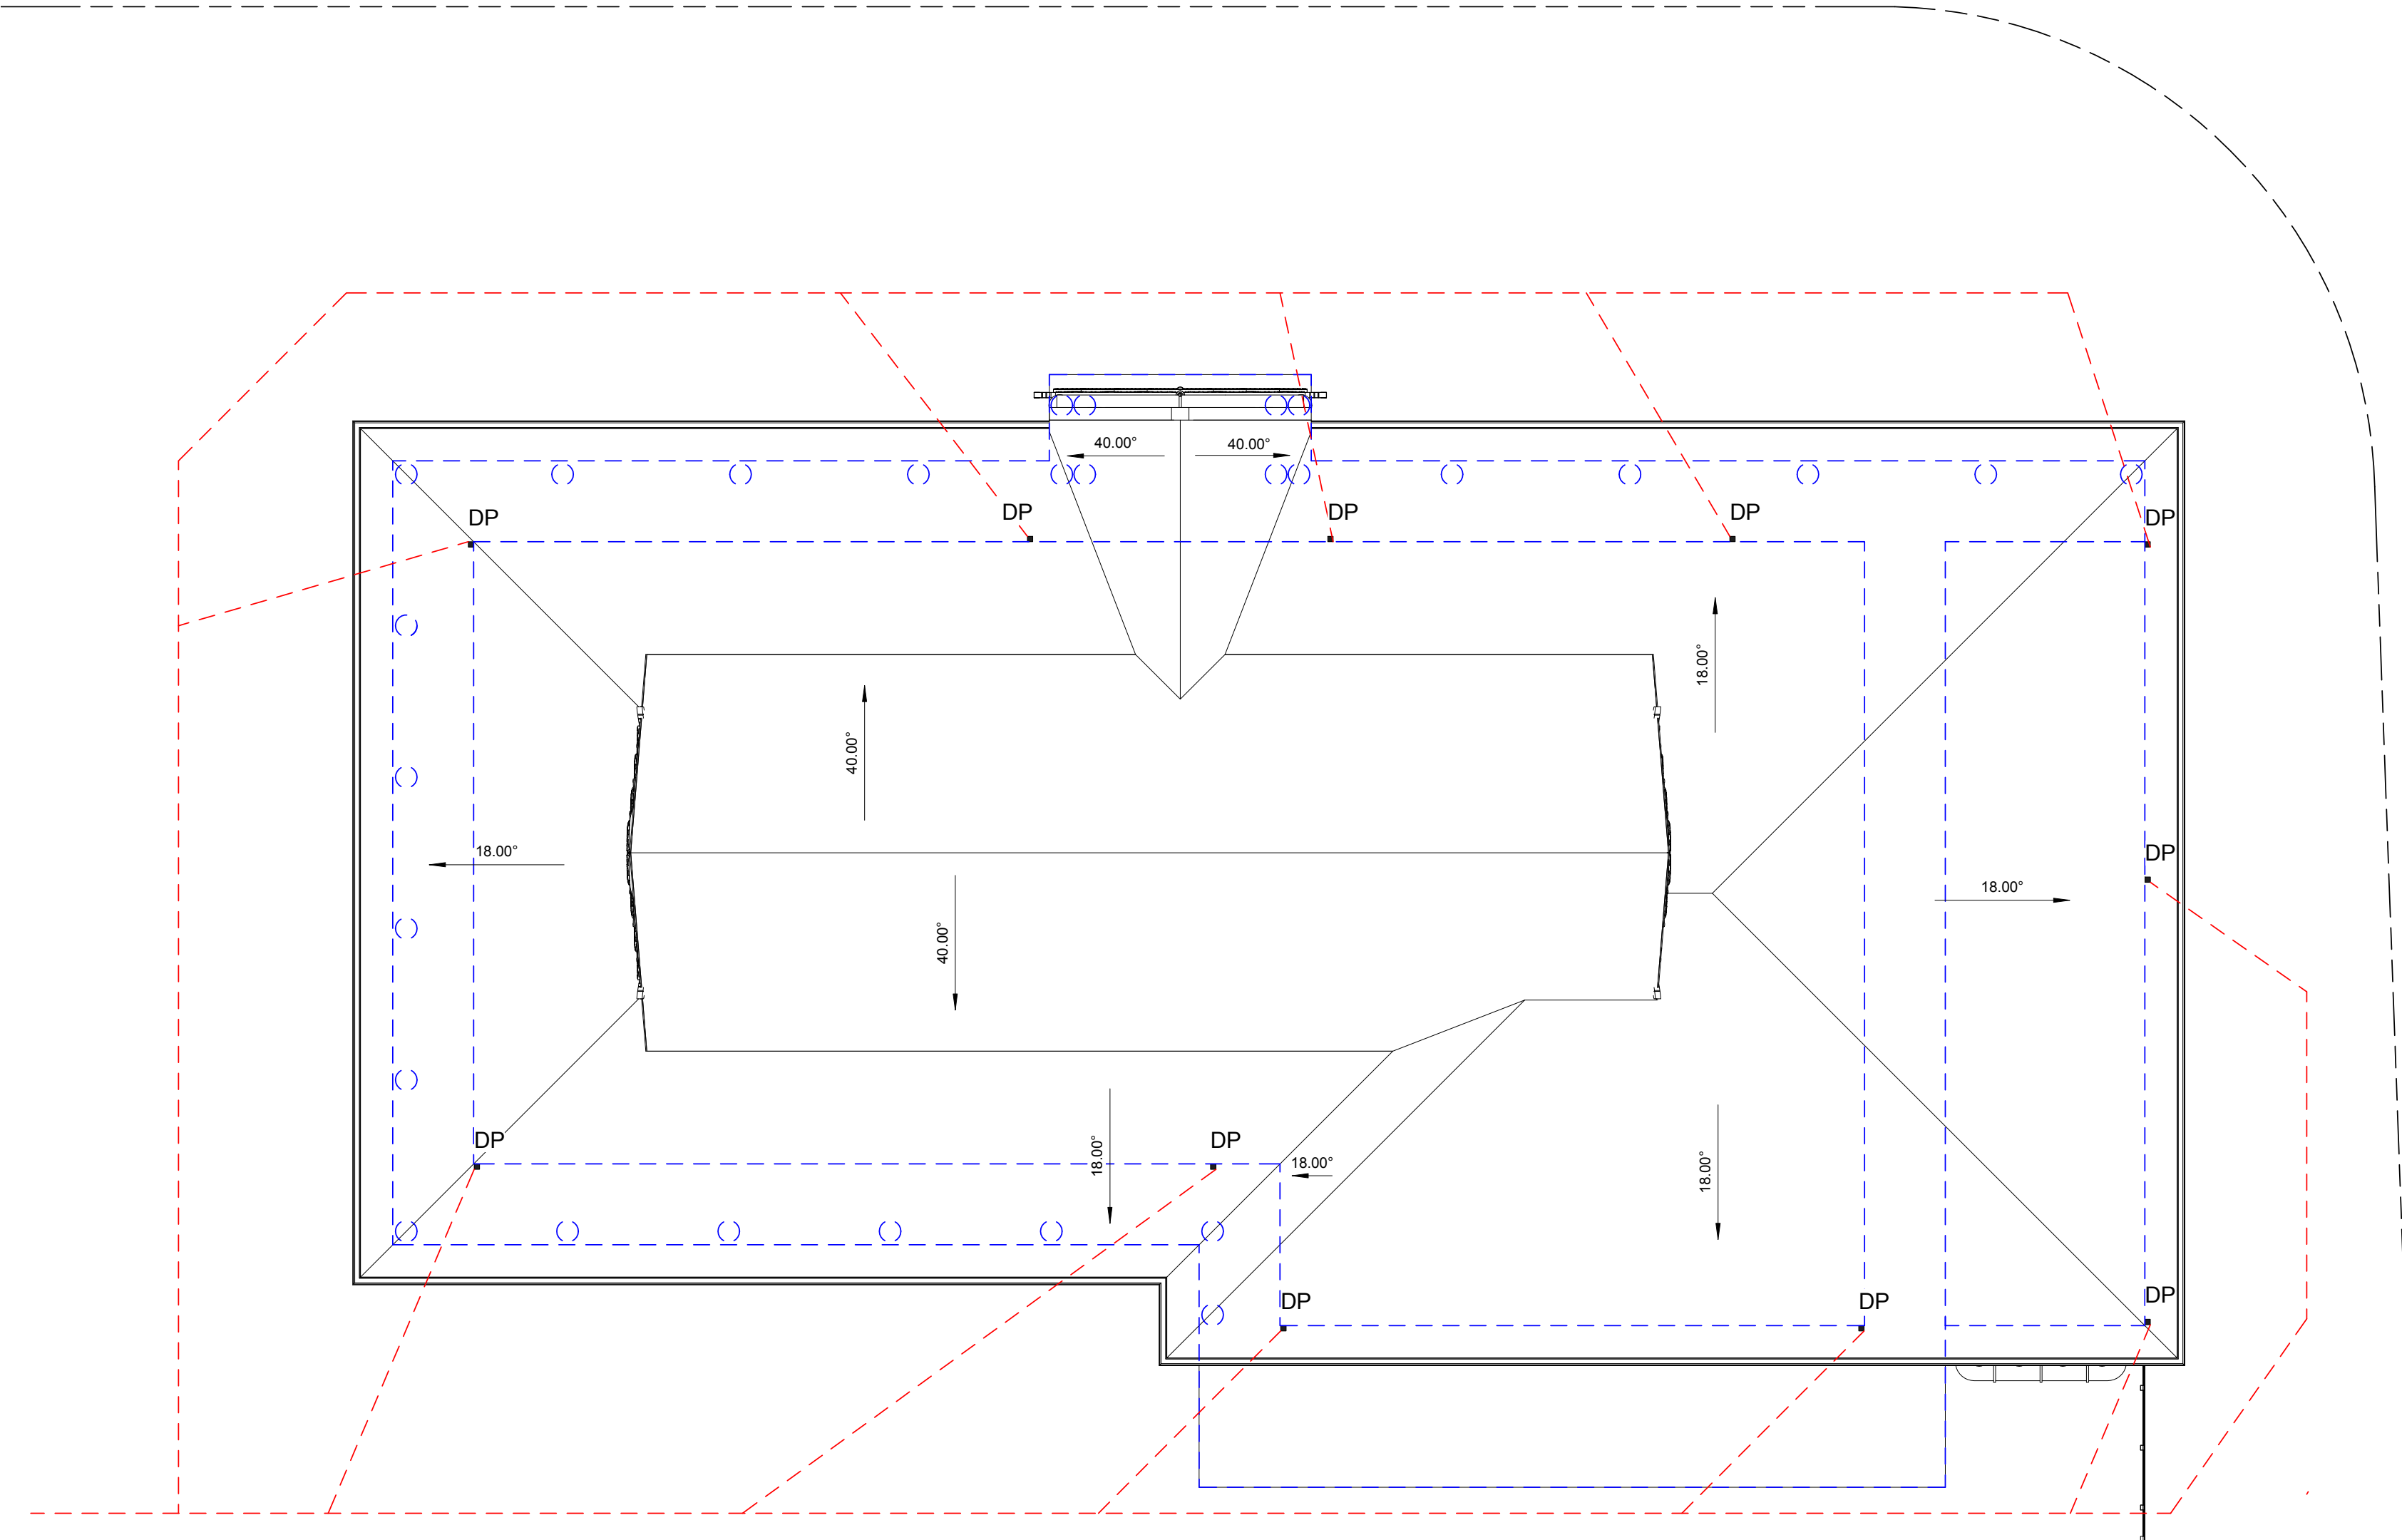


SW & SWGE TIE NOT AVAILABLE  
AT TIME OF DRAFTING

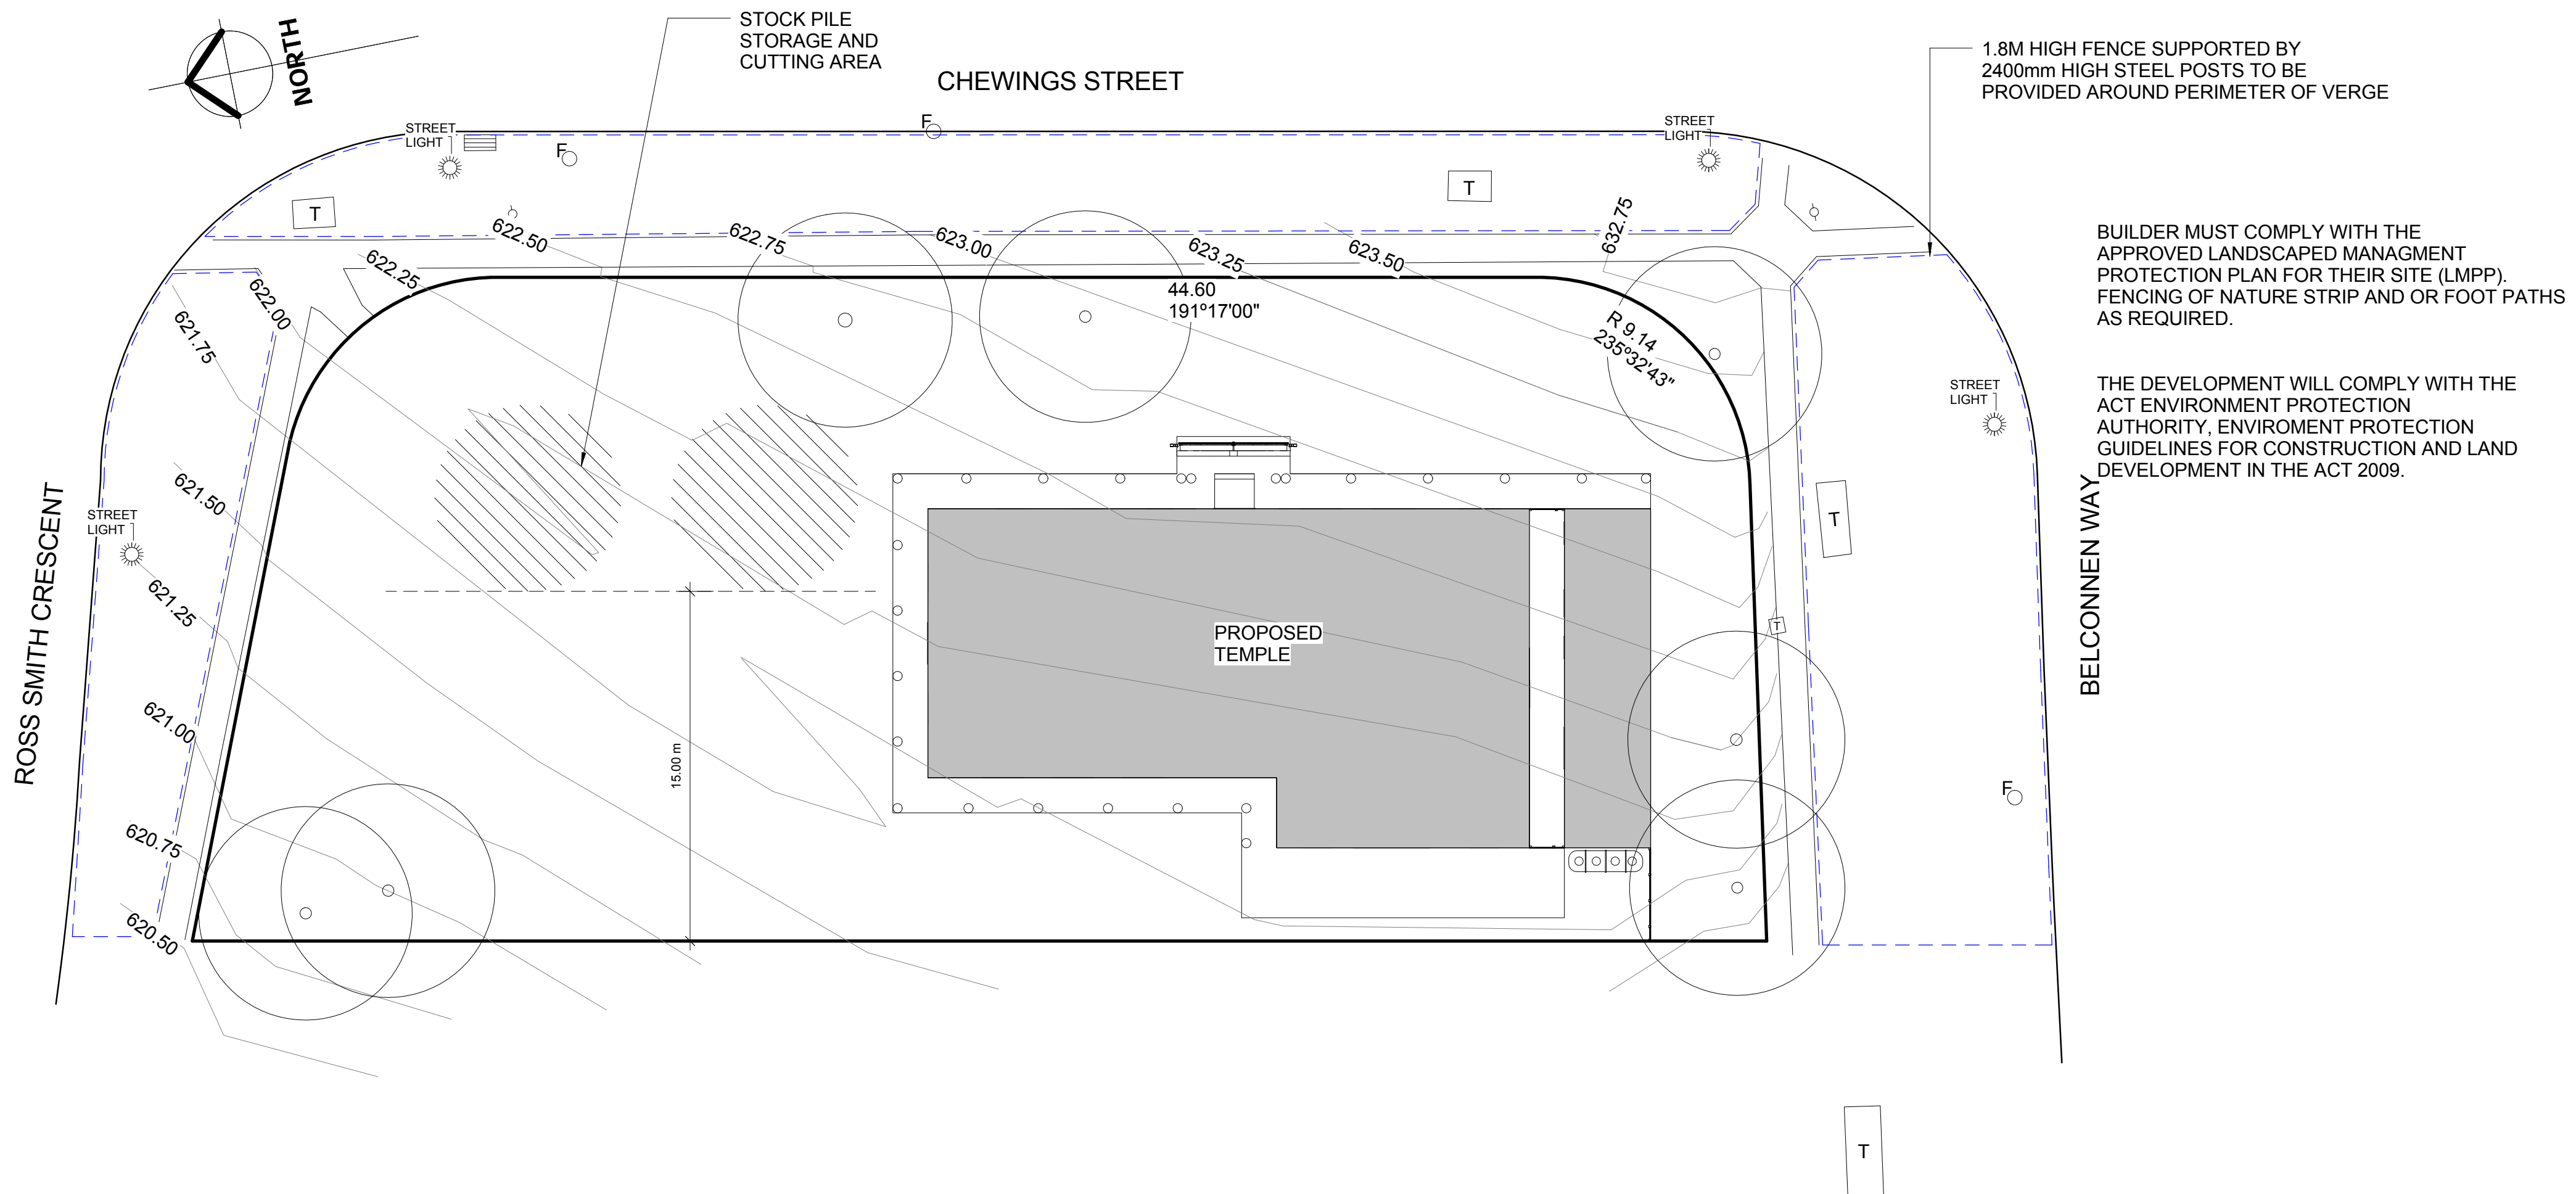




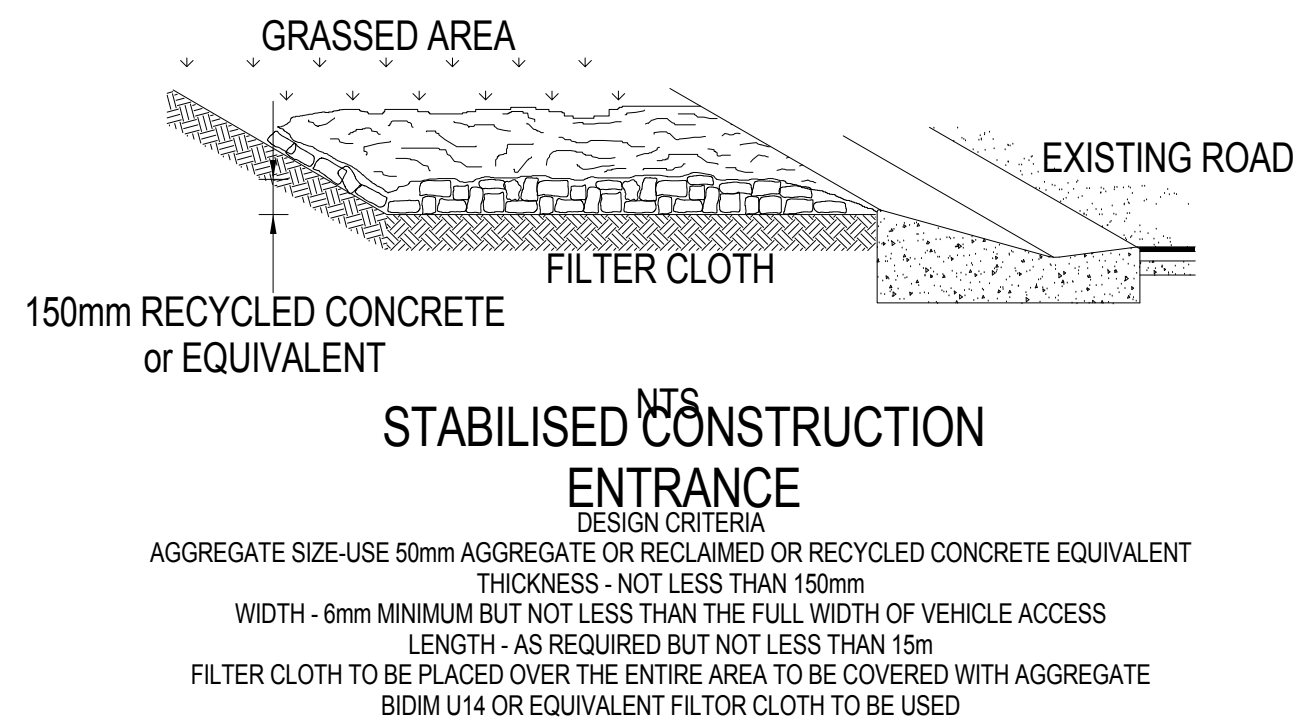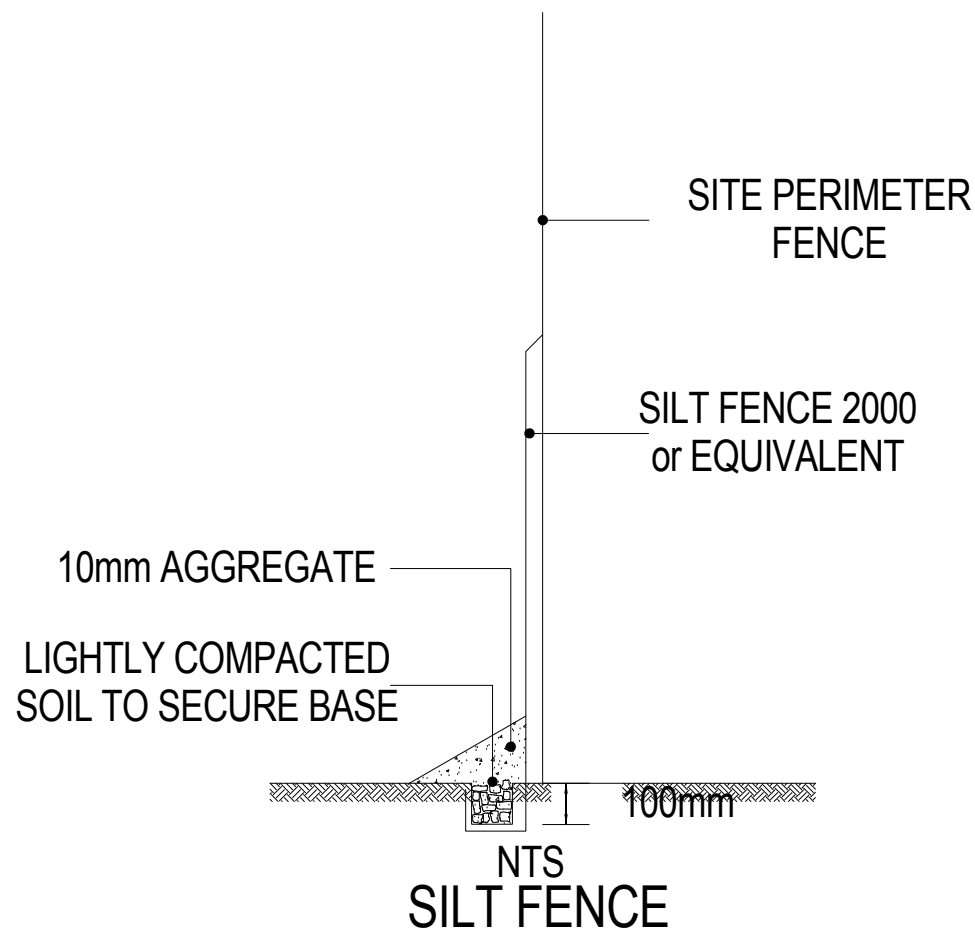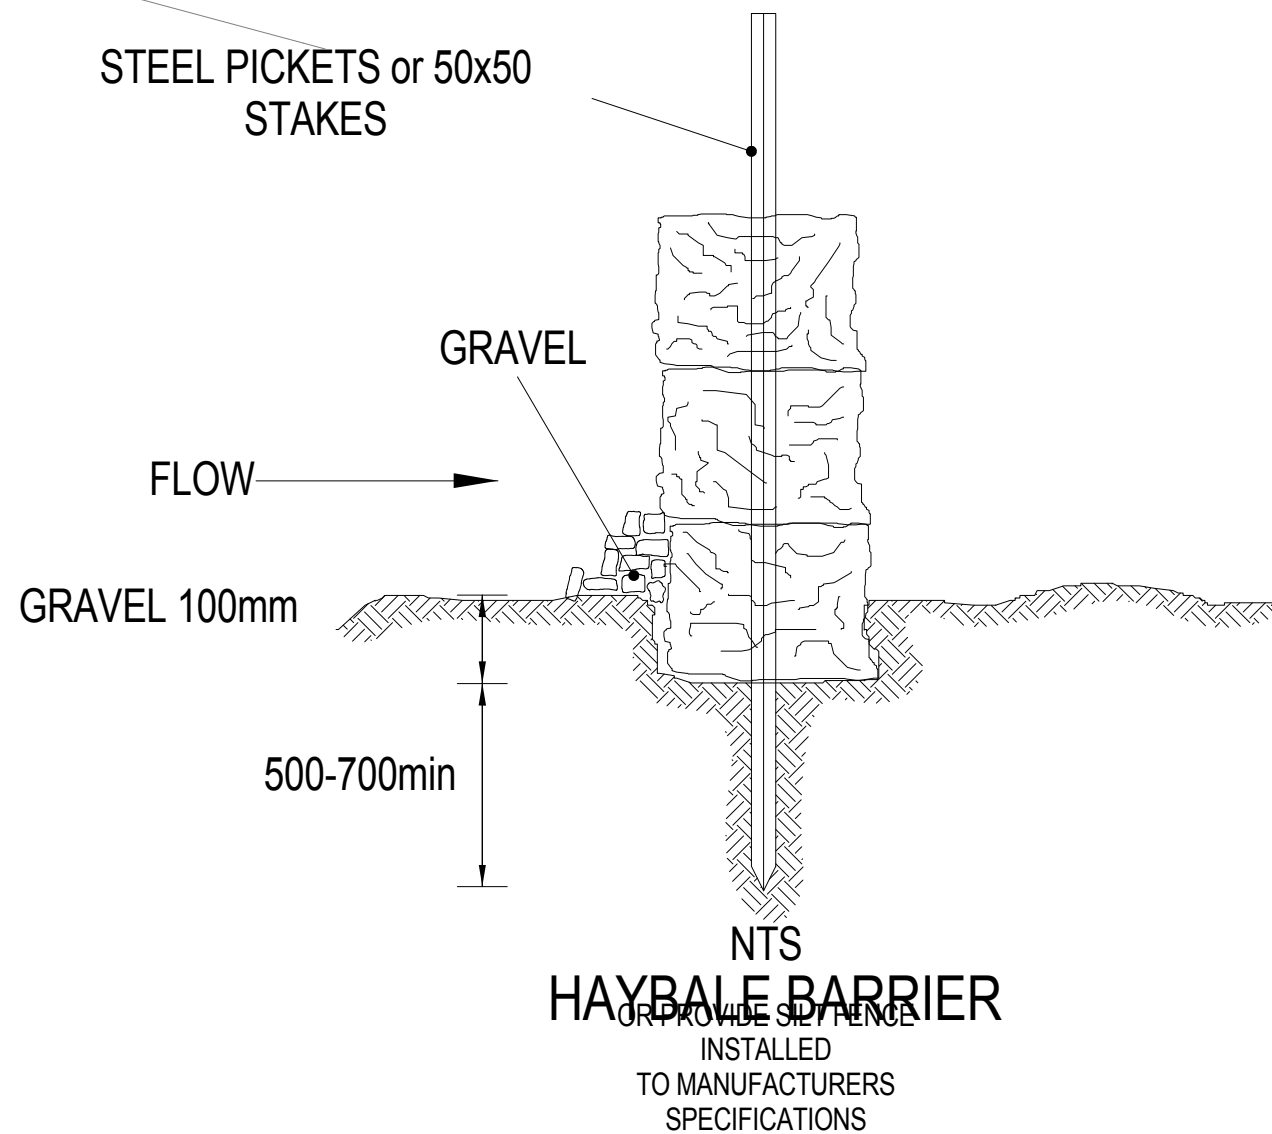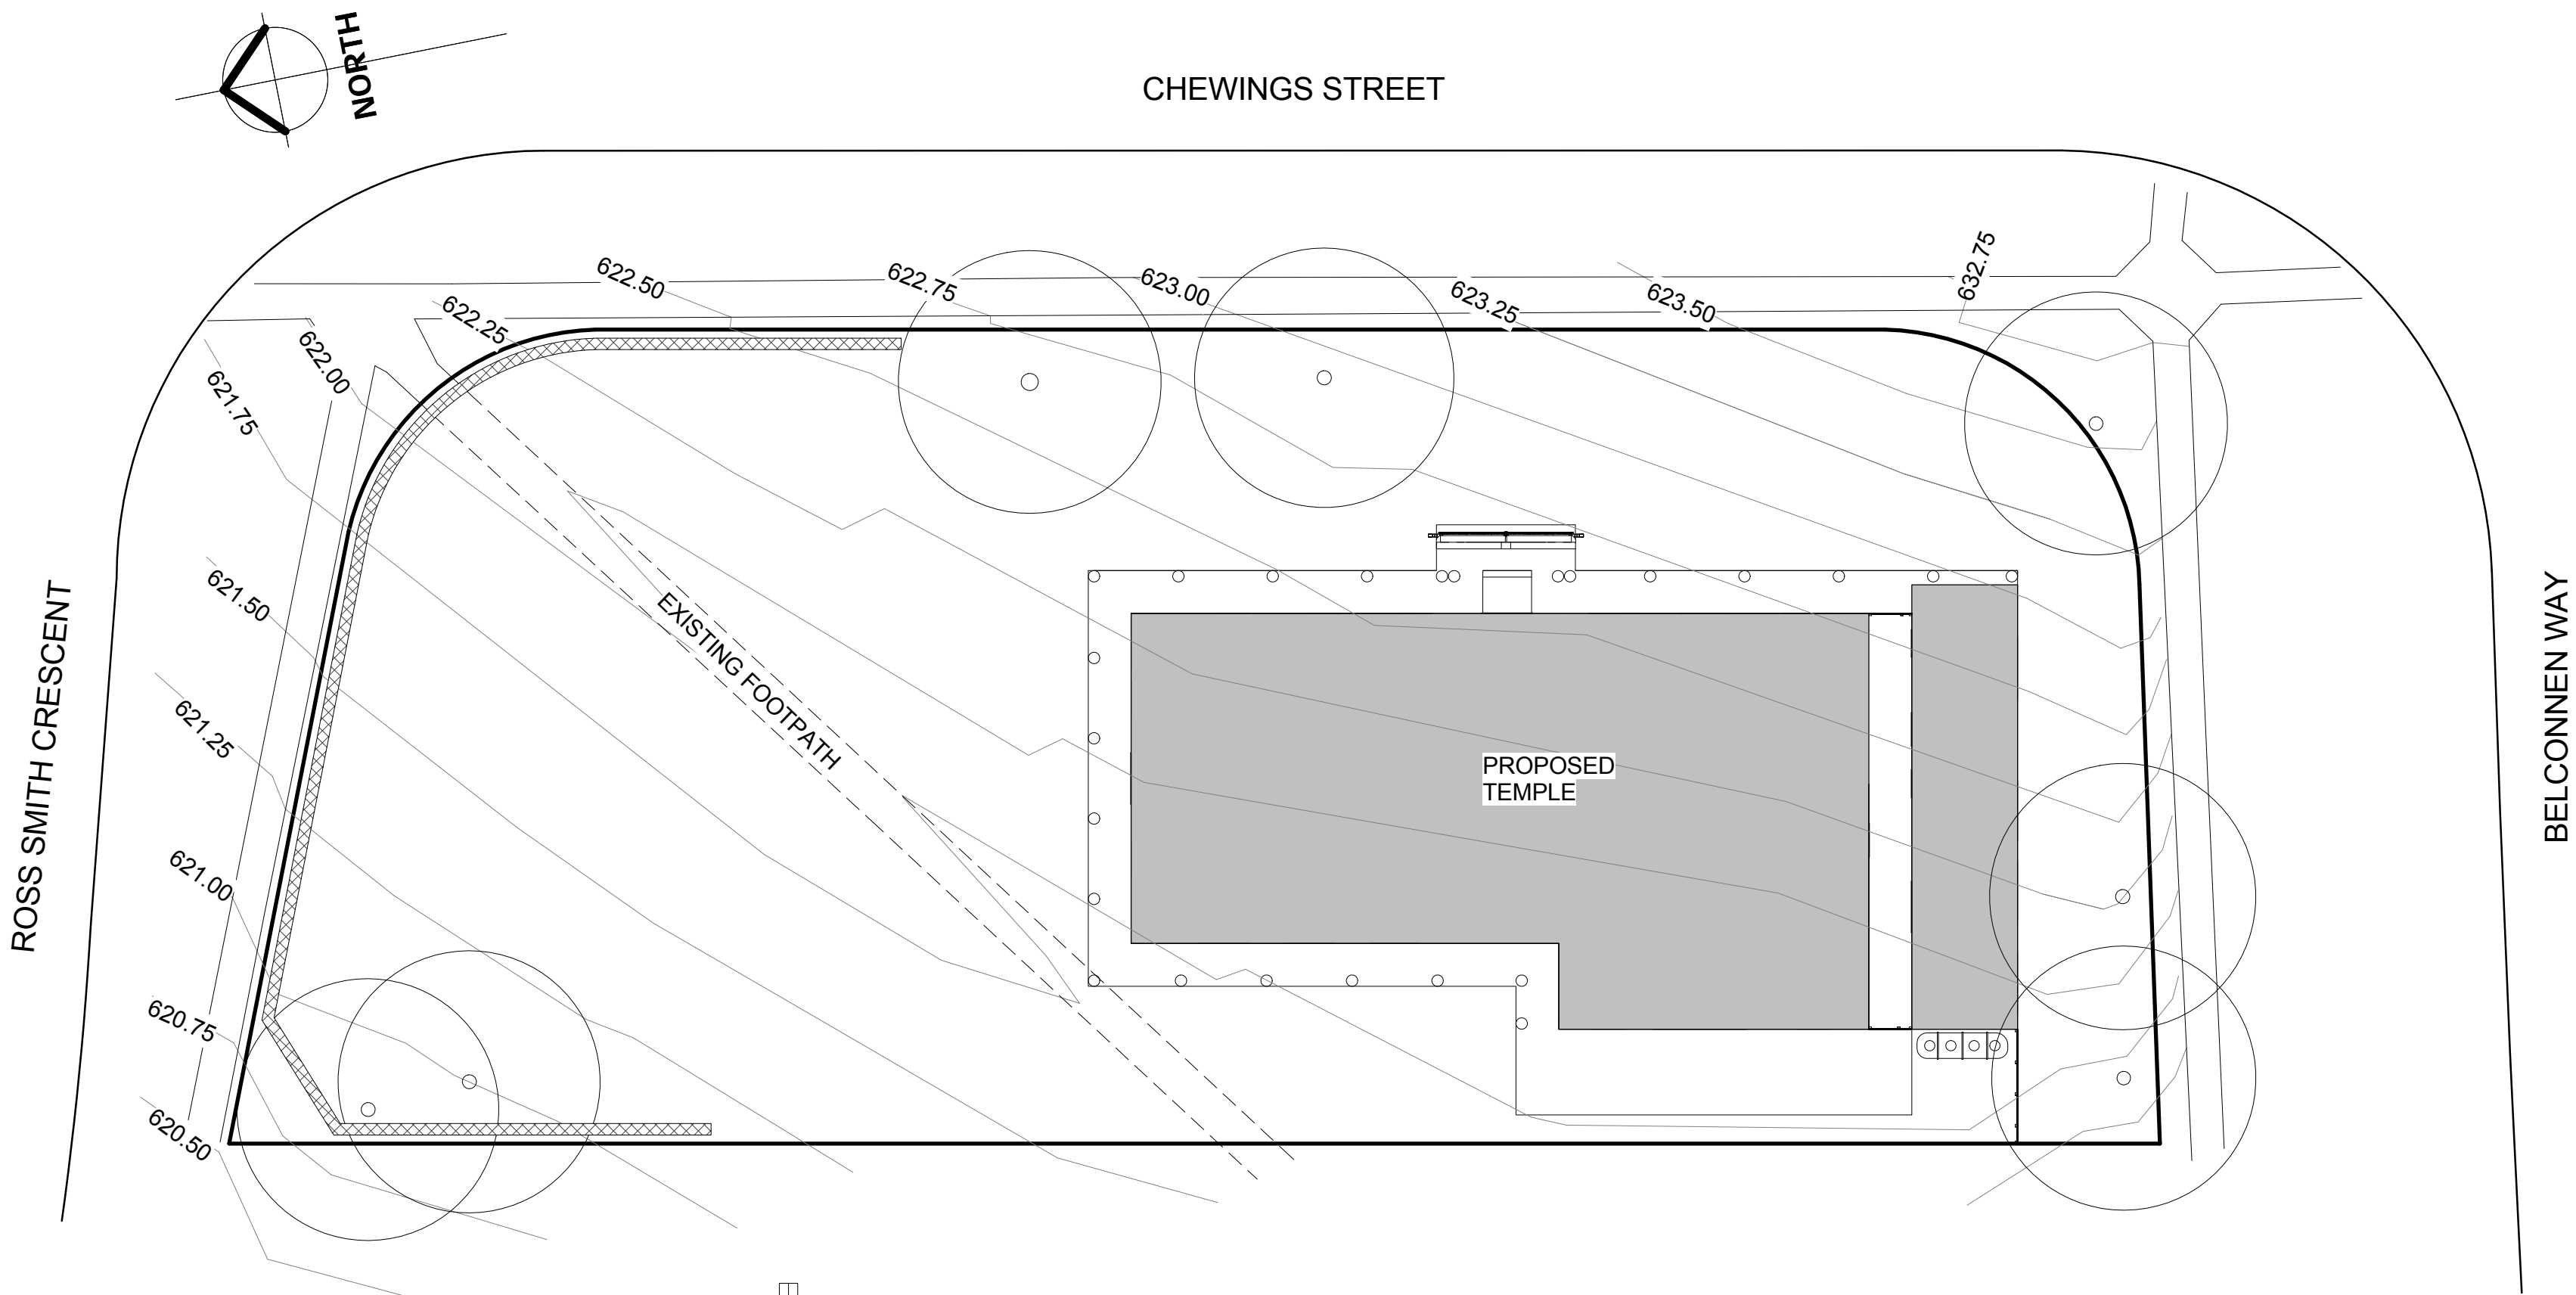

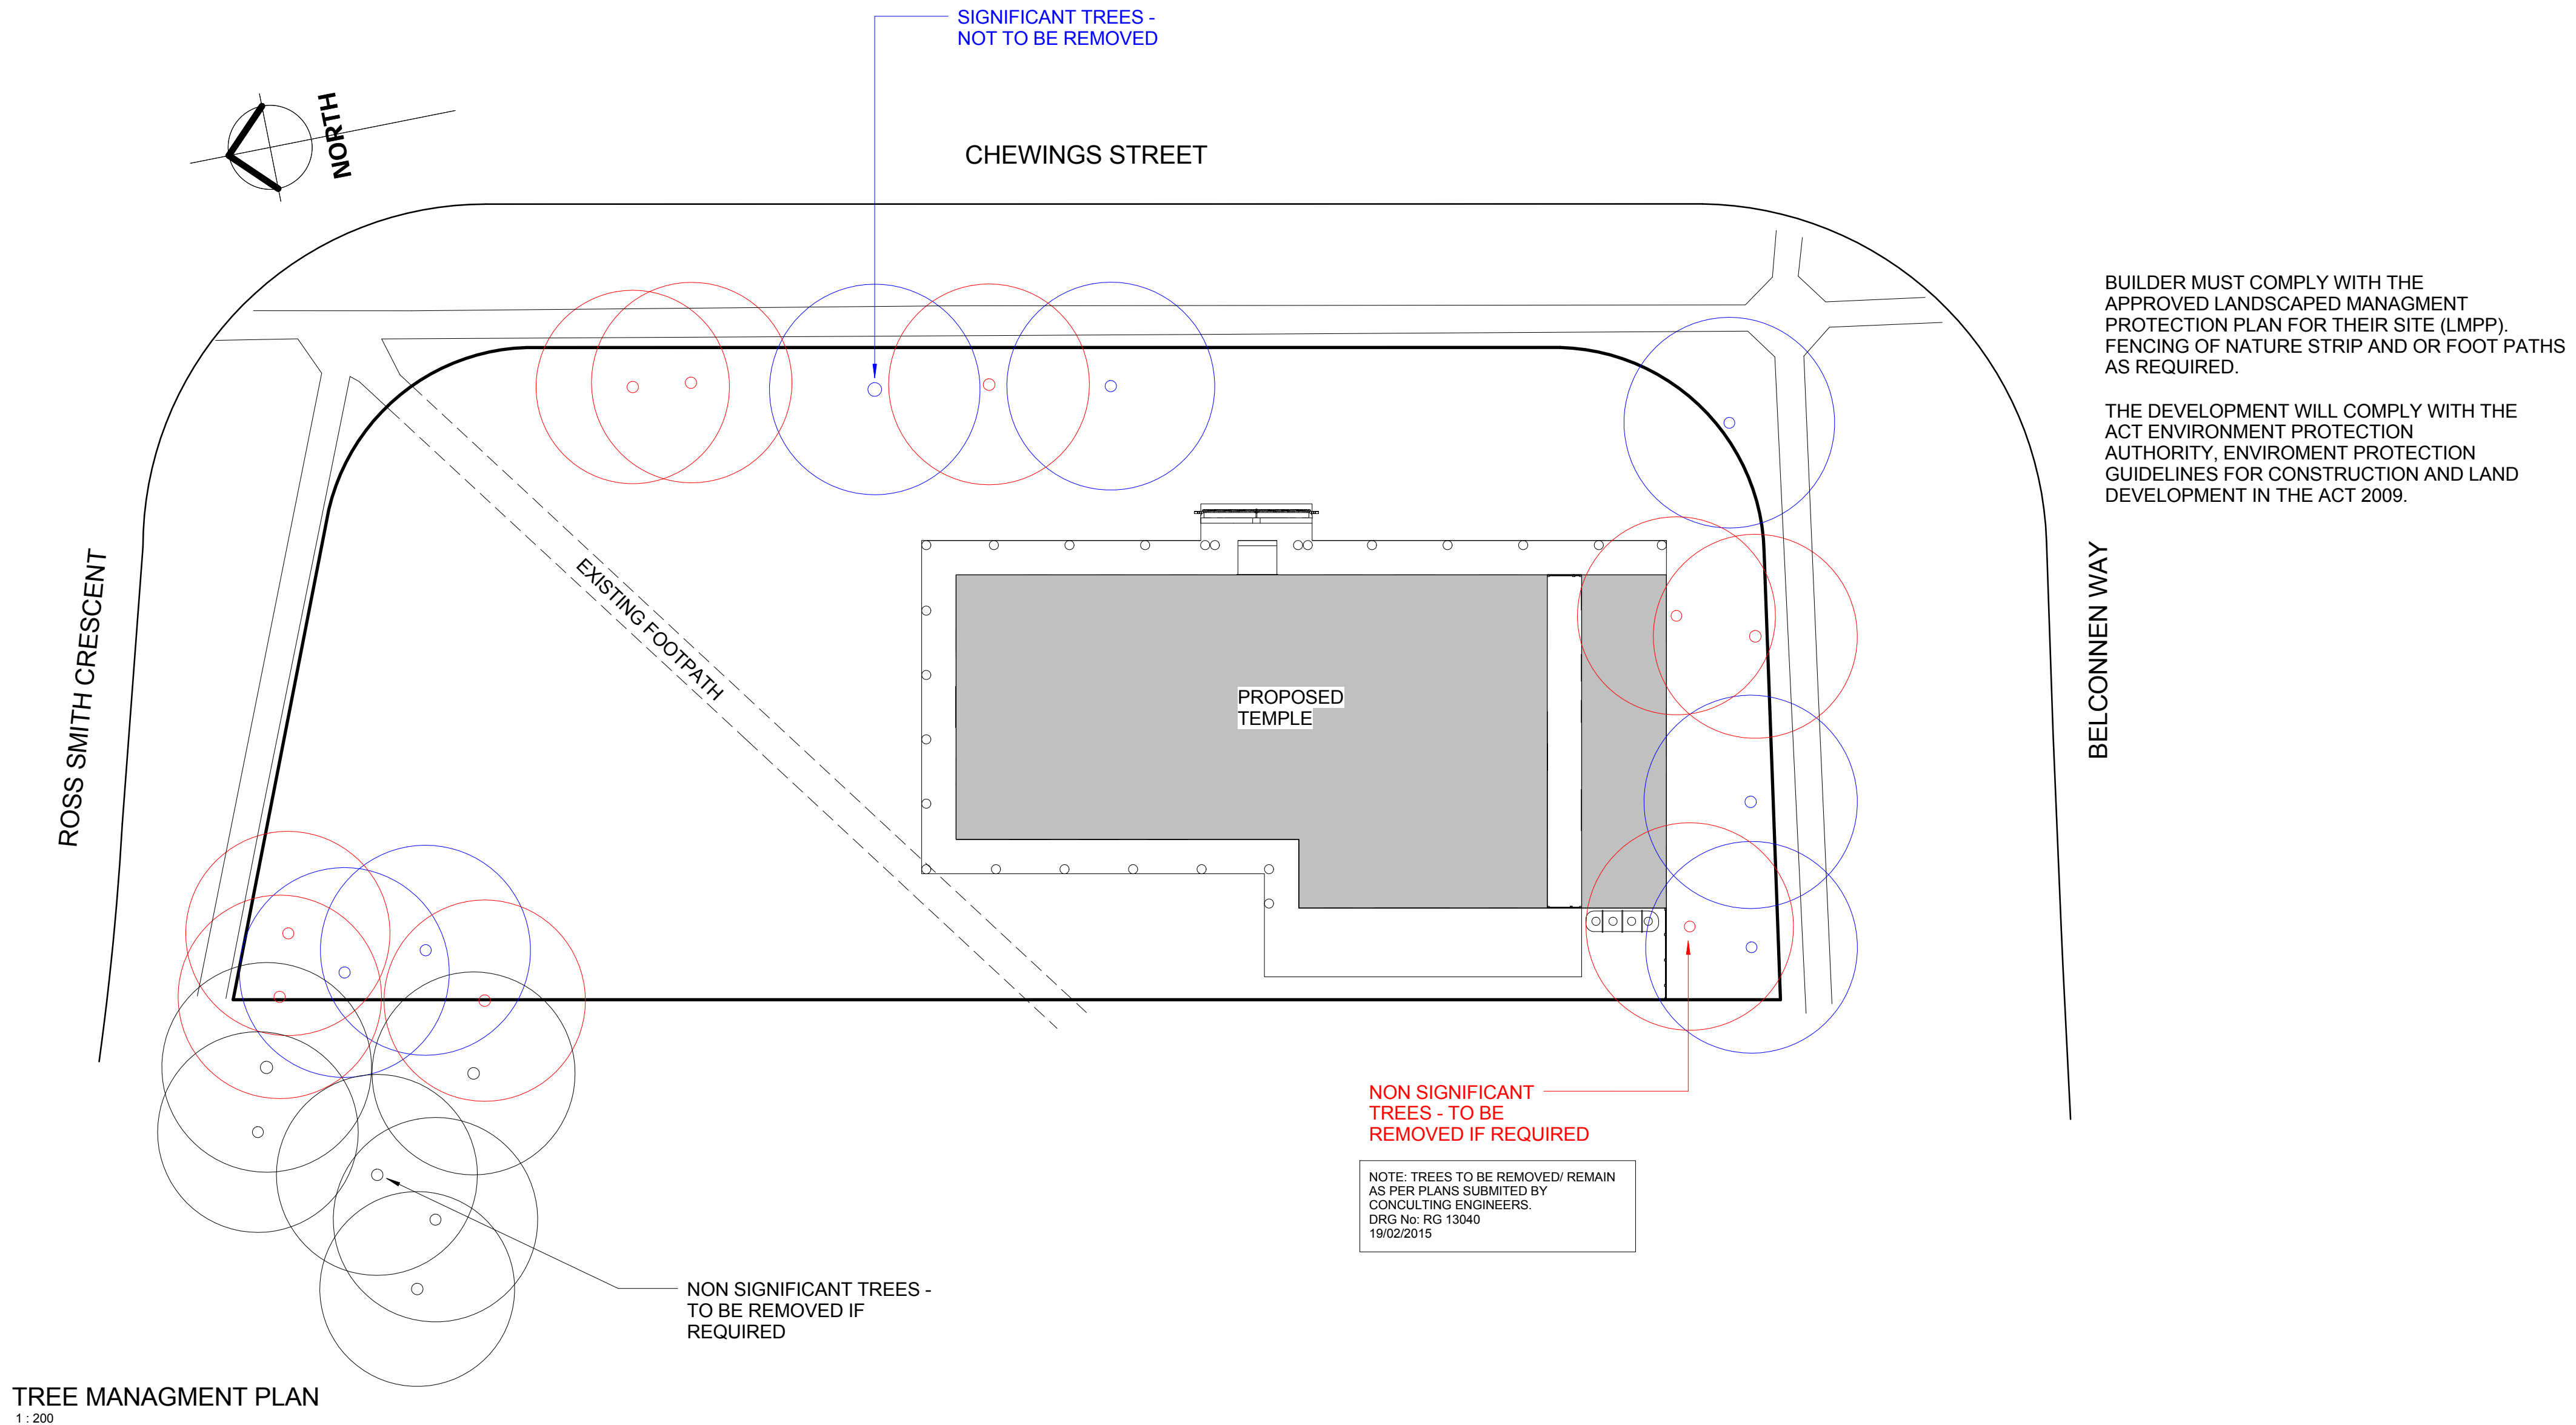



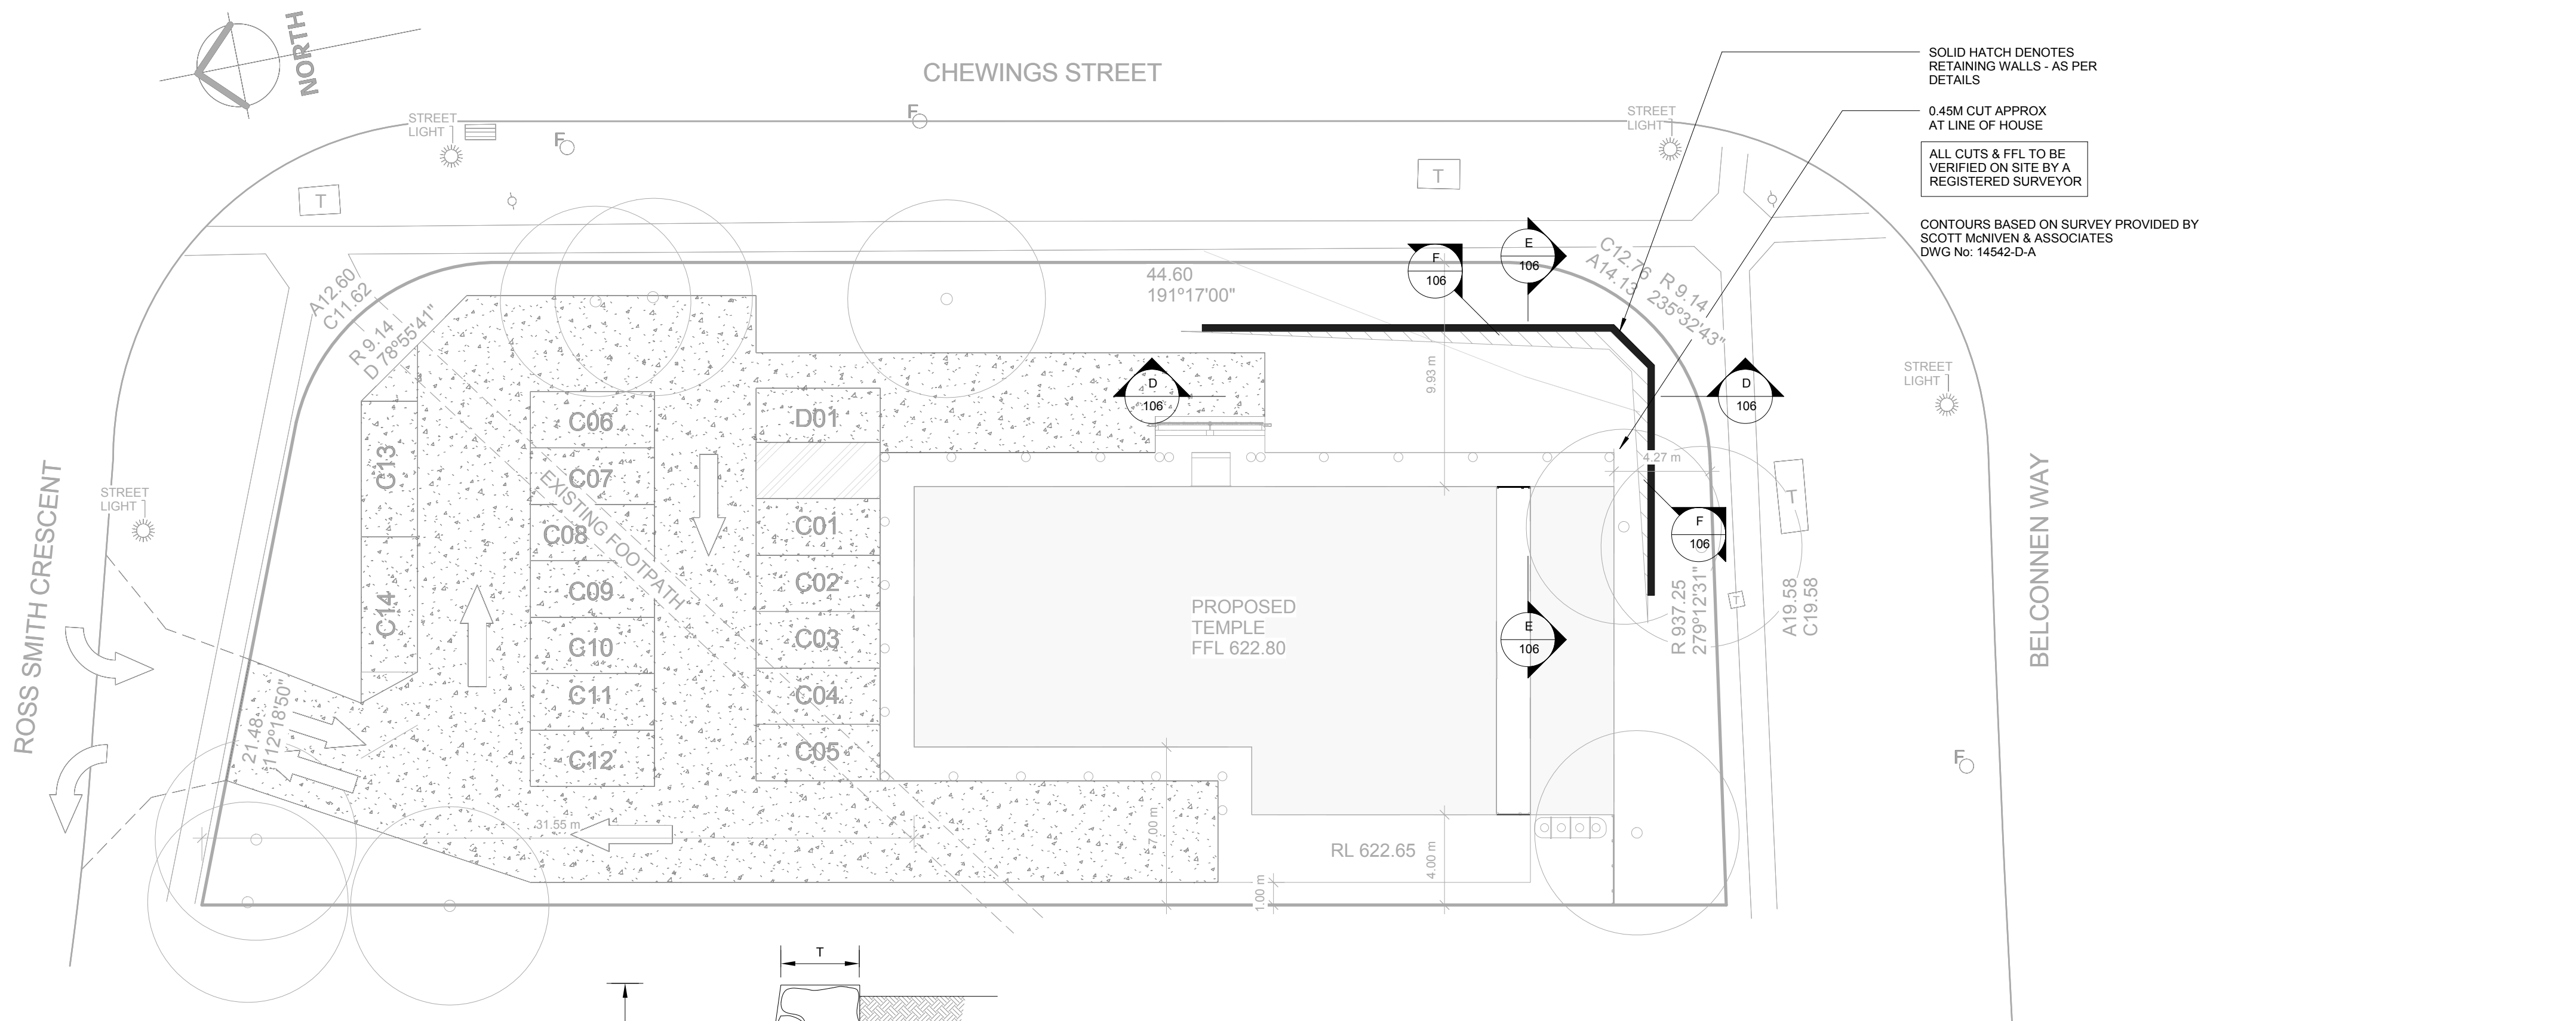


BUILDER TO PROVIDE CRUSHED GRANITE OR AGGREGATES AT ACCESS POINT TO SITE DURING CONSTRUCTION

DRIVEWAY TO COMPLY WITH GW/SD/DC.02 & FINISH TO COMPLY WITH ANY LEASE & DEVELOPMENT CONDITIONS AND RELEVANT LOCAL CODES

SEDIMENT & EROSION CONTROL  
Development complies with the ACT Environment Protection Authority, Environment Protection Guidelines for Construction and Land Development in the ACT August 2007


TOTAL AREA OF HARD LANDSCAPE NOT TO EXCEED 50% AREA OF P.O.S.

RETAINING WALL PLAN  
1 : 200

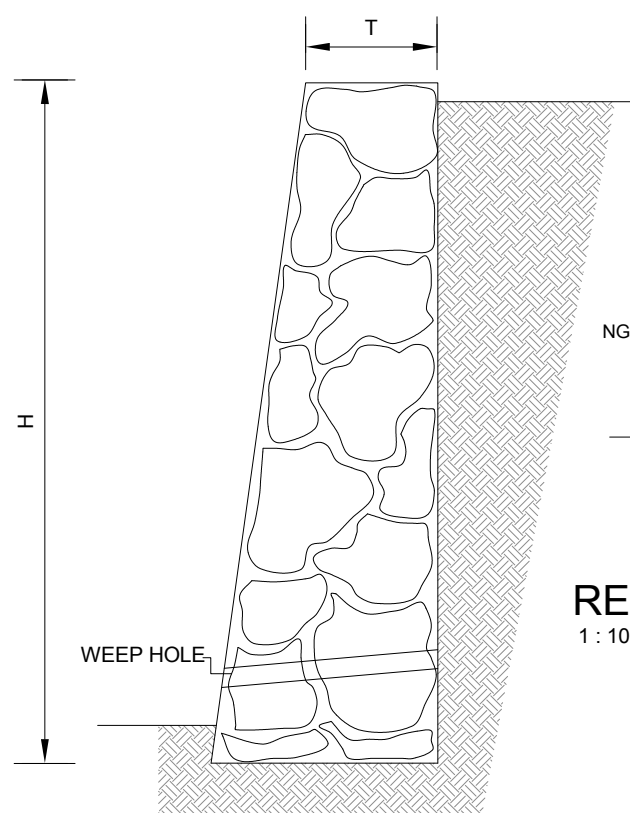


Ww	H	Wf	T
300	900	350	300
500	1500	600	350
600 MAX	1800	700	350
700	2100	800	400


ROCK RETAINING WALL

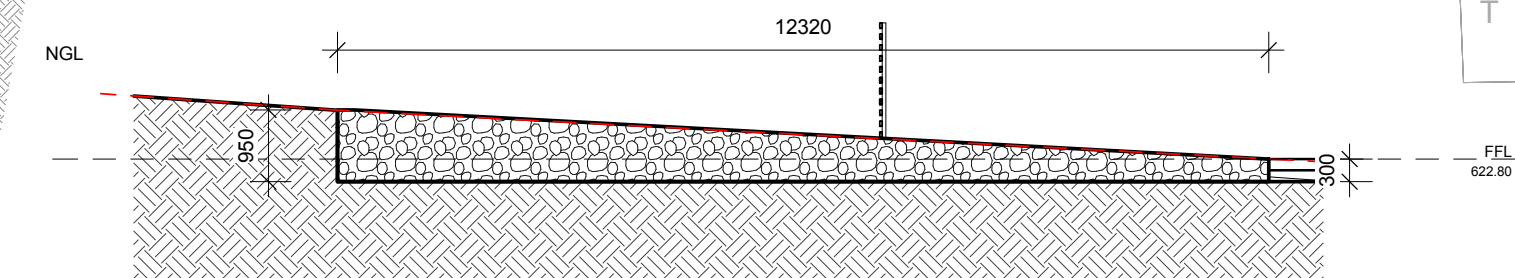

RETAINING E-E  
1 : 100

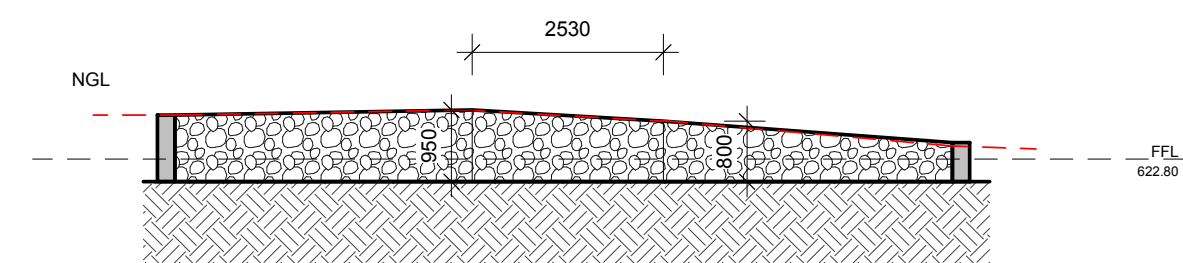

RETAINING F-F  
1 : 100

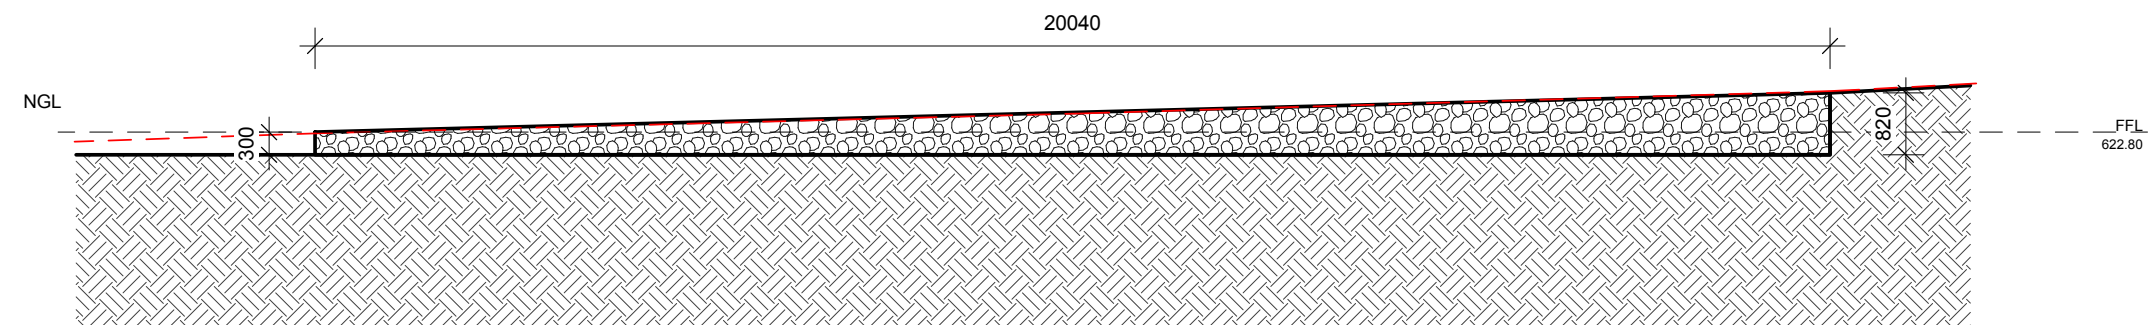

RETAINING D-D  
1 : 100



Building Design, Drafting, Architectural illustrations, BASIX & Energy Ratings  
ABN: 85441177997  
cristian@studio56.com.au  
0403 363 841  
renee@studio56.com.au  
0402 988 379

© COPYRIGHT Studio56  
THIS PLAN REMAINS THE PROPERTY OF Studio56 & MAY NOT BE COPIED IN WHOLE OR IN PART WITHOUT WRITTEN PERMISSION, FAILURE TO DO SO WILL RESULT IN LEGAL ACTION

Client Name: KHEMARARANGSI BUDDHIST TEMPLE OF ACT Inc  
Project : PROPOSED BUDDHIST TEMPLE  
Address: BLOCK 28 SECTION 43 SCULLIN

Sheet Name RETAINING WALLS  
Project number 4017-B DA: 201527708 Scale  
Date 12.08.2015 As indicated  
Drawn by B.LAW Design by C.GONZALEZ

Sheet Number  
106


Rev No





- SENSOR LIGHT AS SELECTED
- BOLLARD LIGHT AS SELECTED
- AMBIENT LIGHTING AS SELECTED

NOTE: A  
ALL LIGHTING TO COMPLY WITH  
AUSTRALIAN STANDARDS  
AS1158 & AS4282

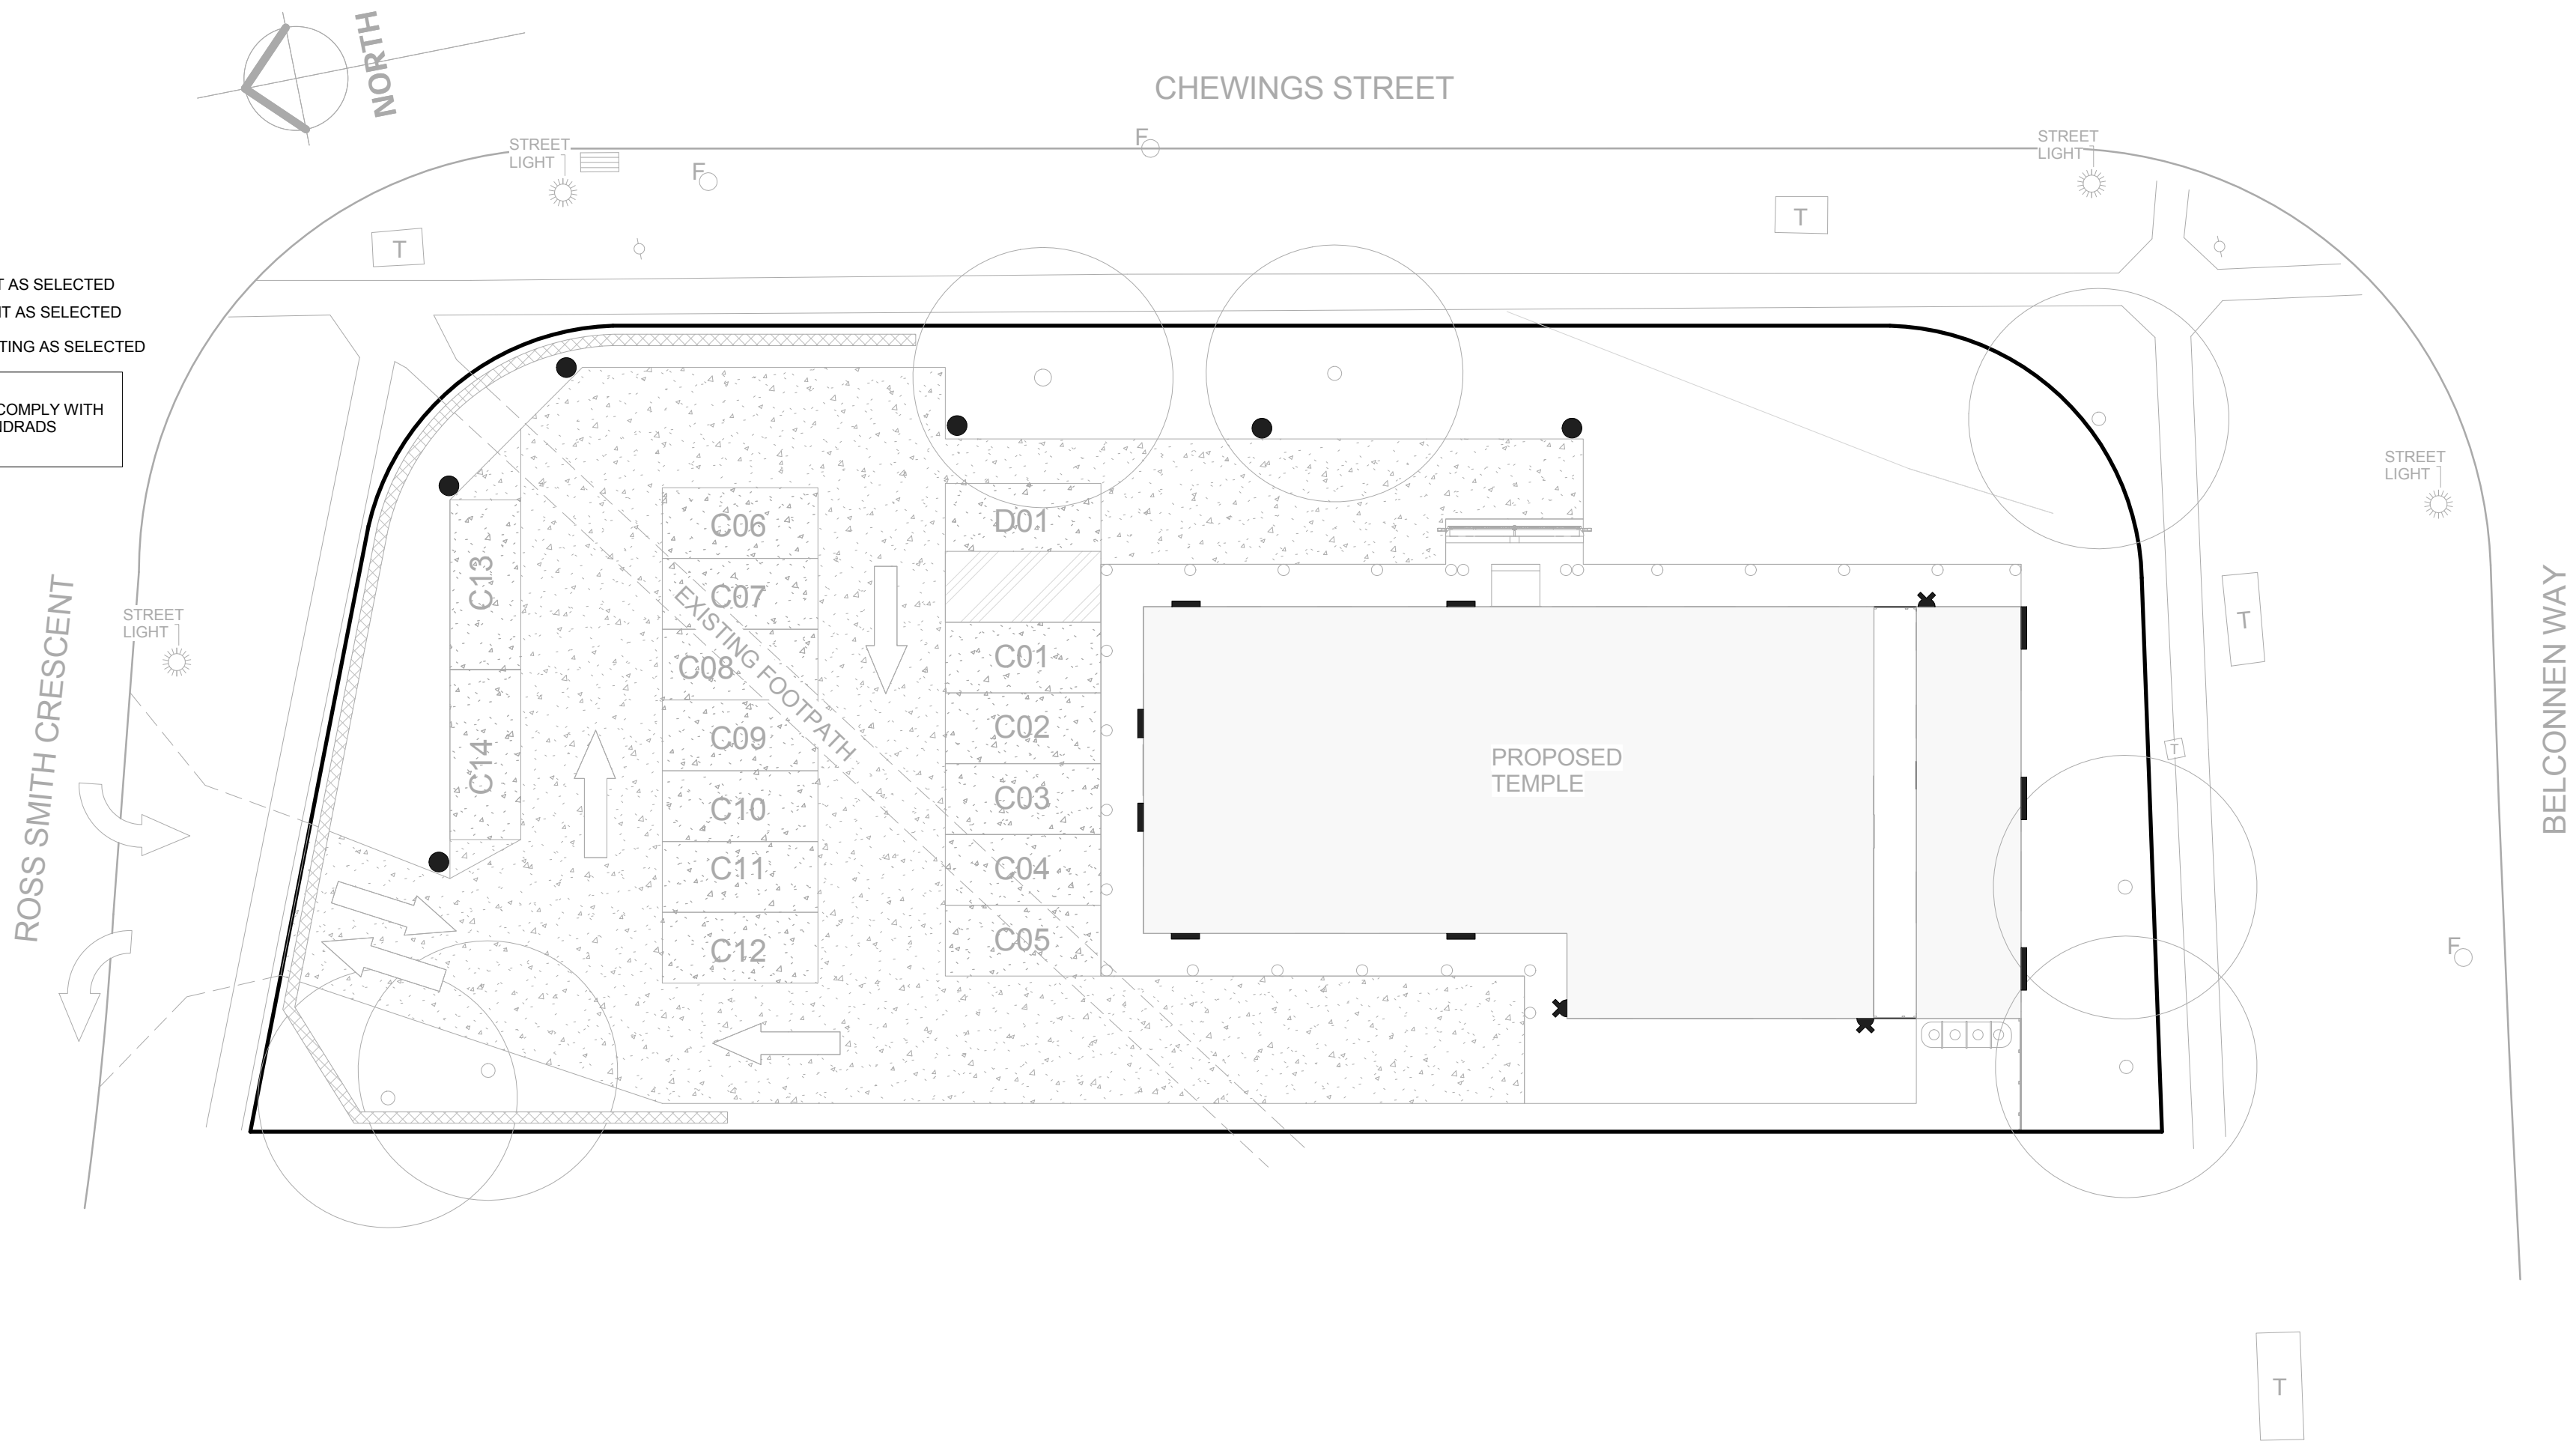


LIGHTING PLAN  
1 : 200

KEY:

EXIT SIGN

EXIT

EMERGENCY LIGHTING

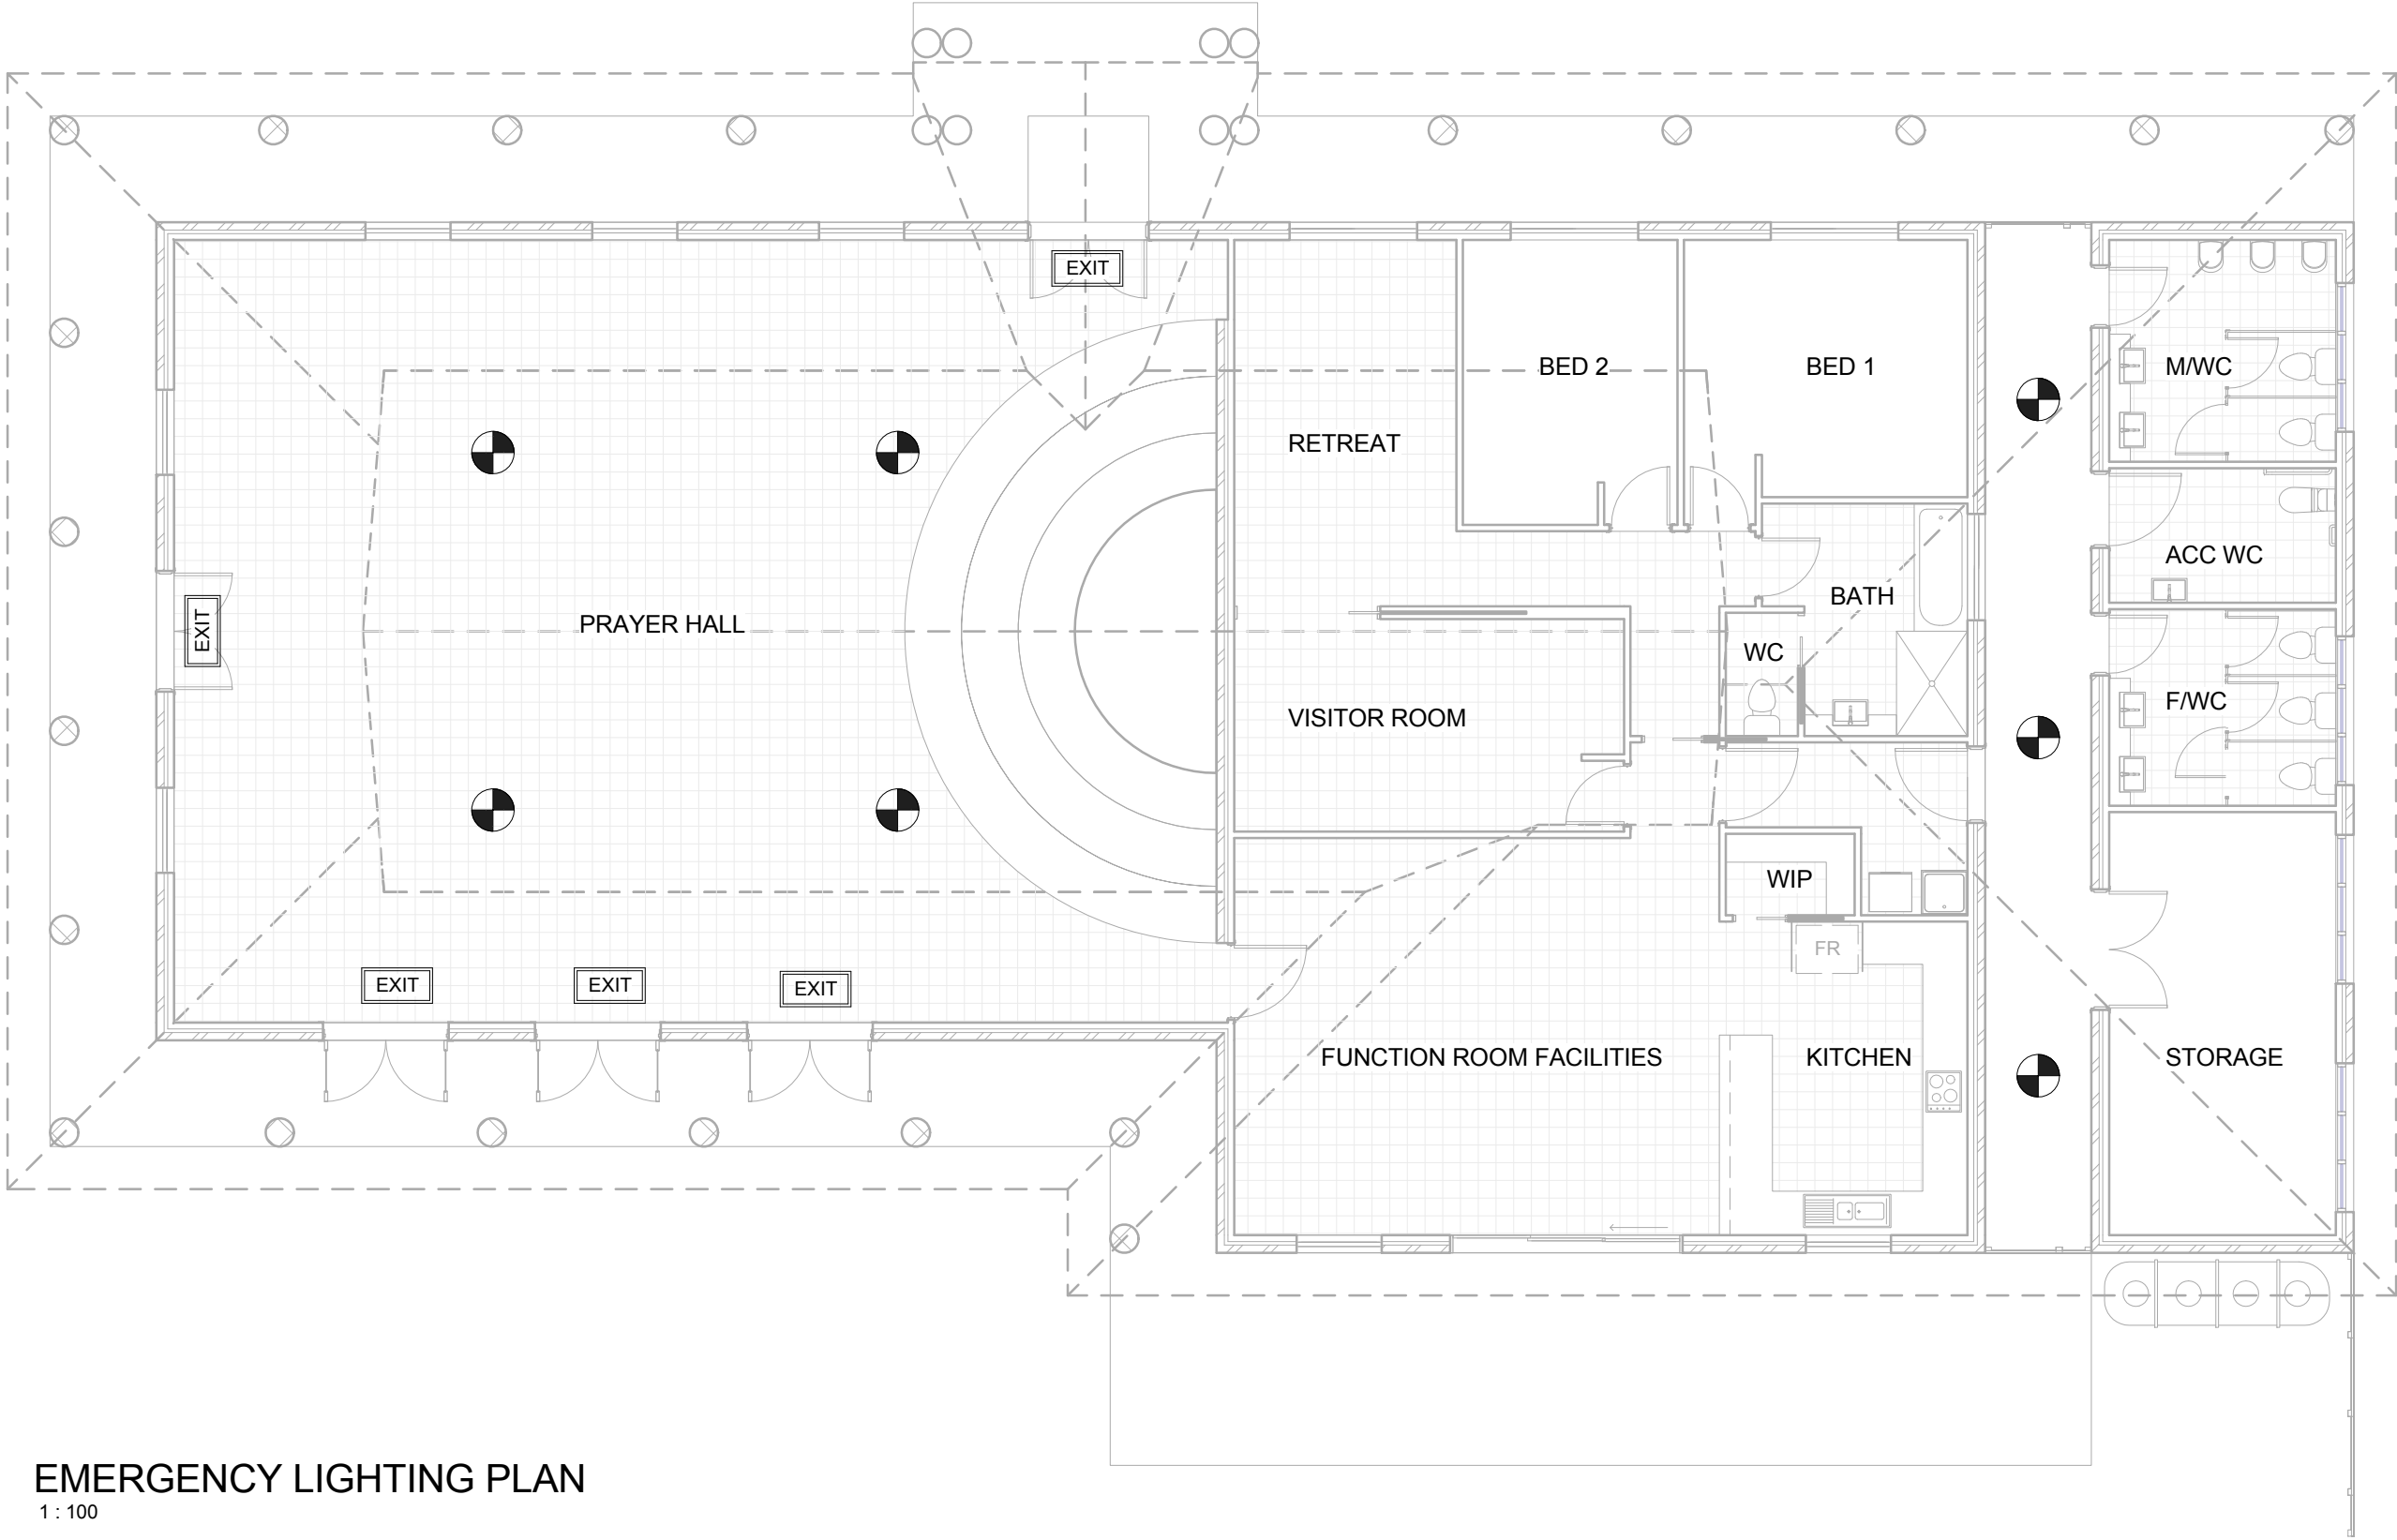

EMERGENCY LIGHTING PLAN  
1 : 100

DOUBLE GPO, 600mm HIGH

DOUBLE GPO, 1050mm HIGH

DOUBLE GPO, VARIABLE HEIGHT

SINGLE GPO, 600mm HIGH

SINGLE GPO, VARIABLE HEIGHT

SINGLE GPO, 1050mm HIGH

SINGLE PHASE, DIRECT CONNECTOR

SWITCH

FLUORESCENT OYSTER LIGHT

LED CEILING LIGHT

DOUBLE FLUORESCENT LIGHT

4 GLOBE TASTIC

SENSOR LIGHT

TV ANTENNA

PHONE OUTLET (RJ 45 SOCKET)

TWO WAY LIGHT SWITCH

DATA POINT

METER BOX

SWITCH BOARD

1

2

3

4

1. ALLOW GPO FOR APPLIANCES SUCH AS DISHWASHER AND RANGEHOOD (NOT SHOWN ON PLAN) FANS, LIGHTS ETC. CENTRED TO ROOM WHERE PRACTICAL

2. A/C UNIT WALL MOUNTED OR OTHERWISE AS REQUIRED

3. ALLOW FOR EXTERNAL GPO WHEN CARPORT ATTACHED

4. ALL GPO'S MIN 600mm ABOVE F.L.

DETAILED LIGHTING PLAN  
1 : 100

**STUDIO 56**

Building Design, Drafting, Architectural  
illustrations, BASIX & Energy Ratings  
ABN: 85441177997  
cristian@studio56.com.au  
0403 363 841  
renee@studio56.com.au  
0402 988 379

© COPYRIGHT **Studio56**  
THIS PLAN REMAINS THE PROPERTY  
OF Studio56 & MAY NOT BE COPIED IN  
WHOLE OR IN PART WITHOUT  
WRITTEN PERMISSION, FAILURE TO DO  
SO WILL RESULT IN LEGAL ACTION

Client Name: KHEMARARANGSI BUDDHIST TEMPLE OF ACT Inc  
Project : PROPOSED BUDDHIST TEMPLE  
Address: BLOCK 28 SECTION 43 SCULLIN

Sheet Name <b>INTERNAL LIGHTING PLAN</b>				
Project number	4017-B	DA: 201527708	Scale	Sheet Number
Date	12.08.2015		1 : 100	<b>110</b>
Drawn by	B.LAW	Design by	B.LAW	
			Rev No	



DOUBLE GPO, 600mm HIGH

DOUBLE GPO, 1050mm HIGH

DOUBLE GPO, VARIABLE HEIGHT

SINGLE GPO, 600mm HIGH

SINGLE GPO, VARIABLE HEIGHT

SINGLE GPO, 1050mm HIGH

SINGLE PHASE, DIRECT CONNECTOR

SWITCH

FLUORESCENT OYSTER LIGHT

LED CEILING LIGHT

DOUBLE FLUORESCENT LIGHT

4 GLOBE TASTIC

SENSOR LIGHT

TV ANTENNA

PHONE OUTLET (RJ 45 SOCKET)

TWO WAY LIGHT SWITCH

DATA POINT

METER BOX

SWITCH BOARD

ELECTRICAL LEGEND

ELECTRICAL NOTES

1. ALLOW GPO FOR APPLIANCES SUCH AS DISHWASHER AND RANGEHOOD (NOT SHOWN ON PLAN) FANS, LIGHTS ETC. CENTRED TO ROOM WHERE PRACTICAL

2. A/C UNIT WALL MOUNTED OR OTHERWISE AS REQUIRED

3. ALLOW FOR EXTERNAL GPO WHEN CARPORT ATTACHED

4. ALL GPO'S MIN 600mm ABOVE F.L.

STUDIO 56

Building Design, Drafting, Architectural illustrations, BASIX & Energy Ratings

ABN: 85441177997

cristian@studio56.com.au

0403 363 841

renee@studio56.com.au

0402 988 379

© COPYRIGHT Studio56

THIS PLAN REMAINS THE PROPERTY OF Studio56 & MAY NOT BE COPIED IN WHOLE OR IN PART WITHOUT WRITTEN PERMISSION, FAILURE TO DO SO WILL RESULT IN LEGAL ACTION

Client Name: KHEMARARANGSI BUDDHIST TEMPLE OF ACT Inc

Project : PROPOSED BUDDHIST TEMPLE

Address: BLOCK 28 SECTION 43 SCULLIN

Sheet Name POWER PLAN

Project number 4017-B DA: 201527708


Date 12.08.2015


Drawn by B.LAW Design by B.LAW

Scale 1 : 100

Sheet Number 111

Rev No

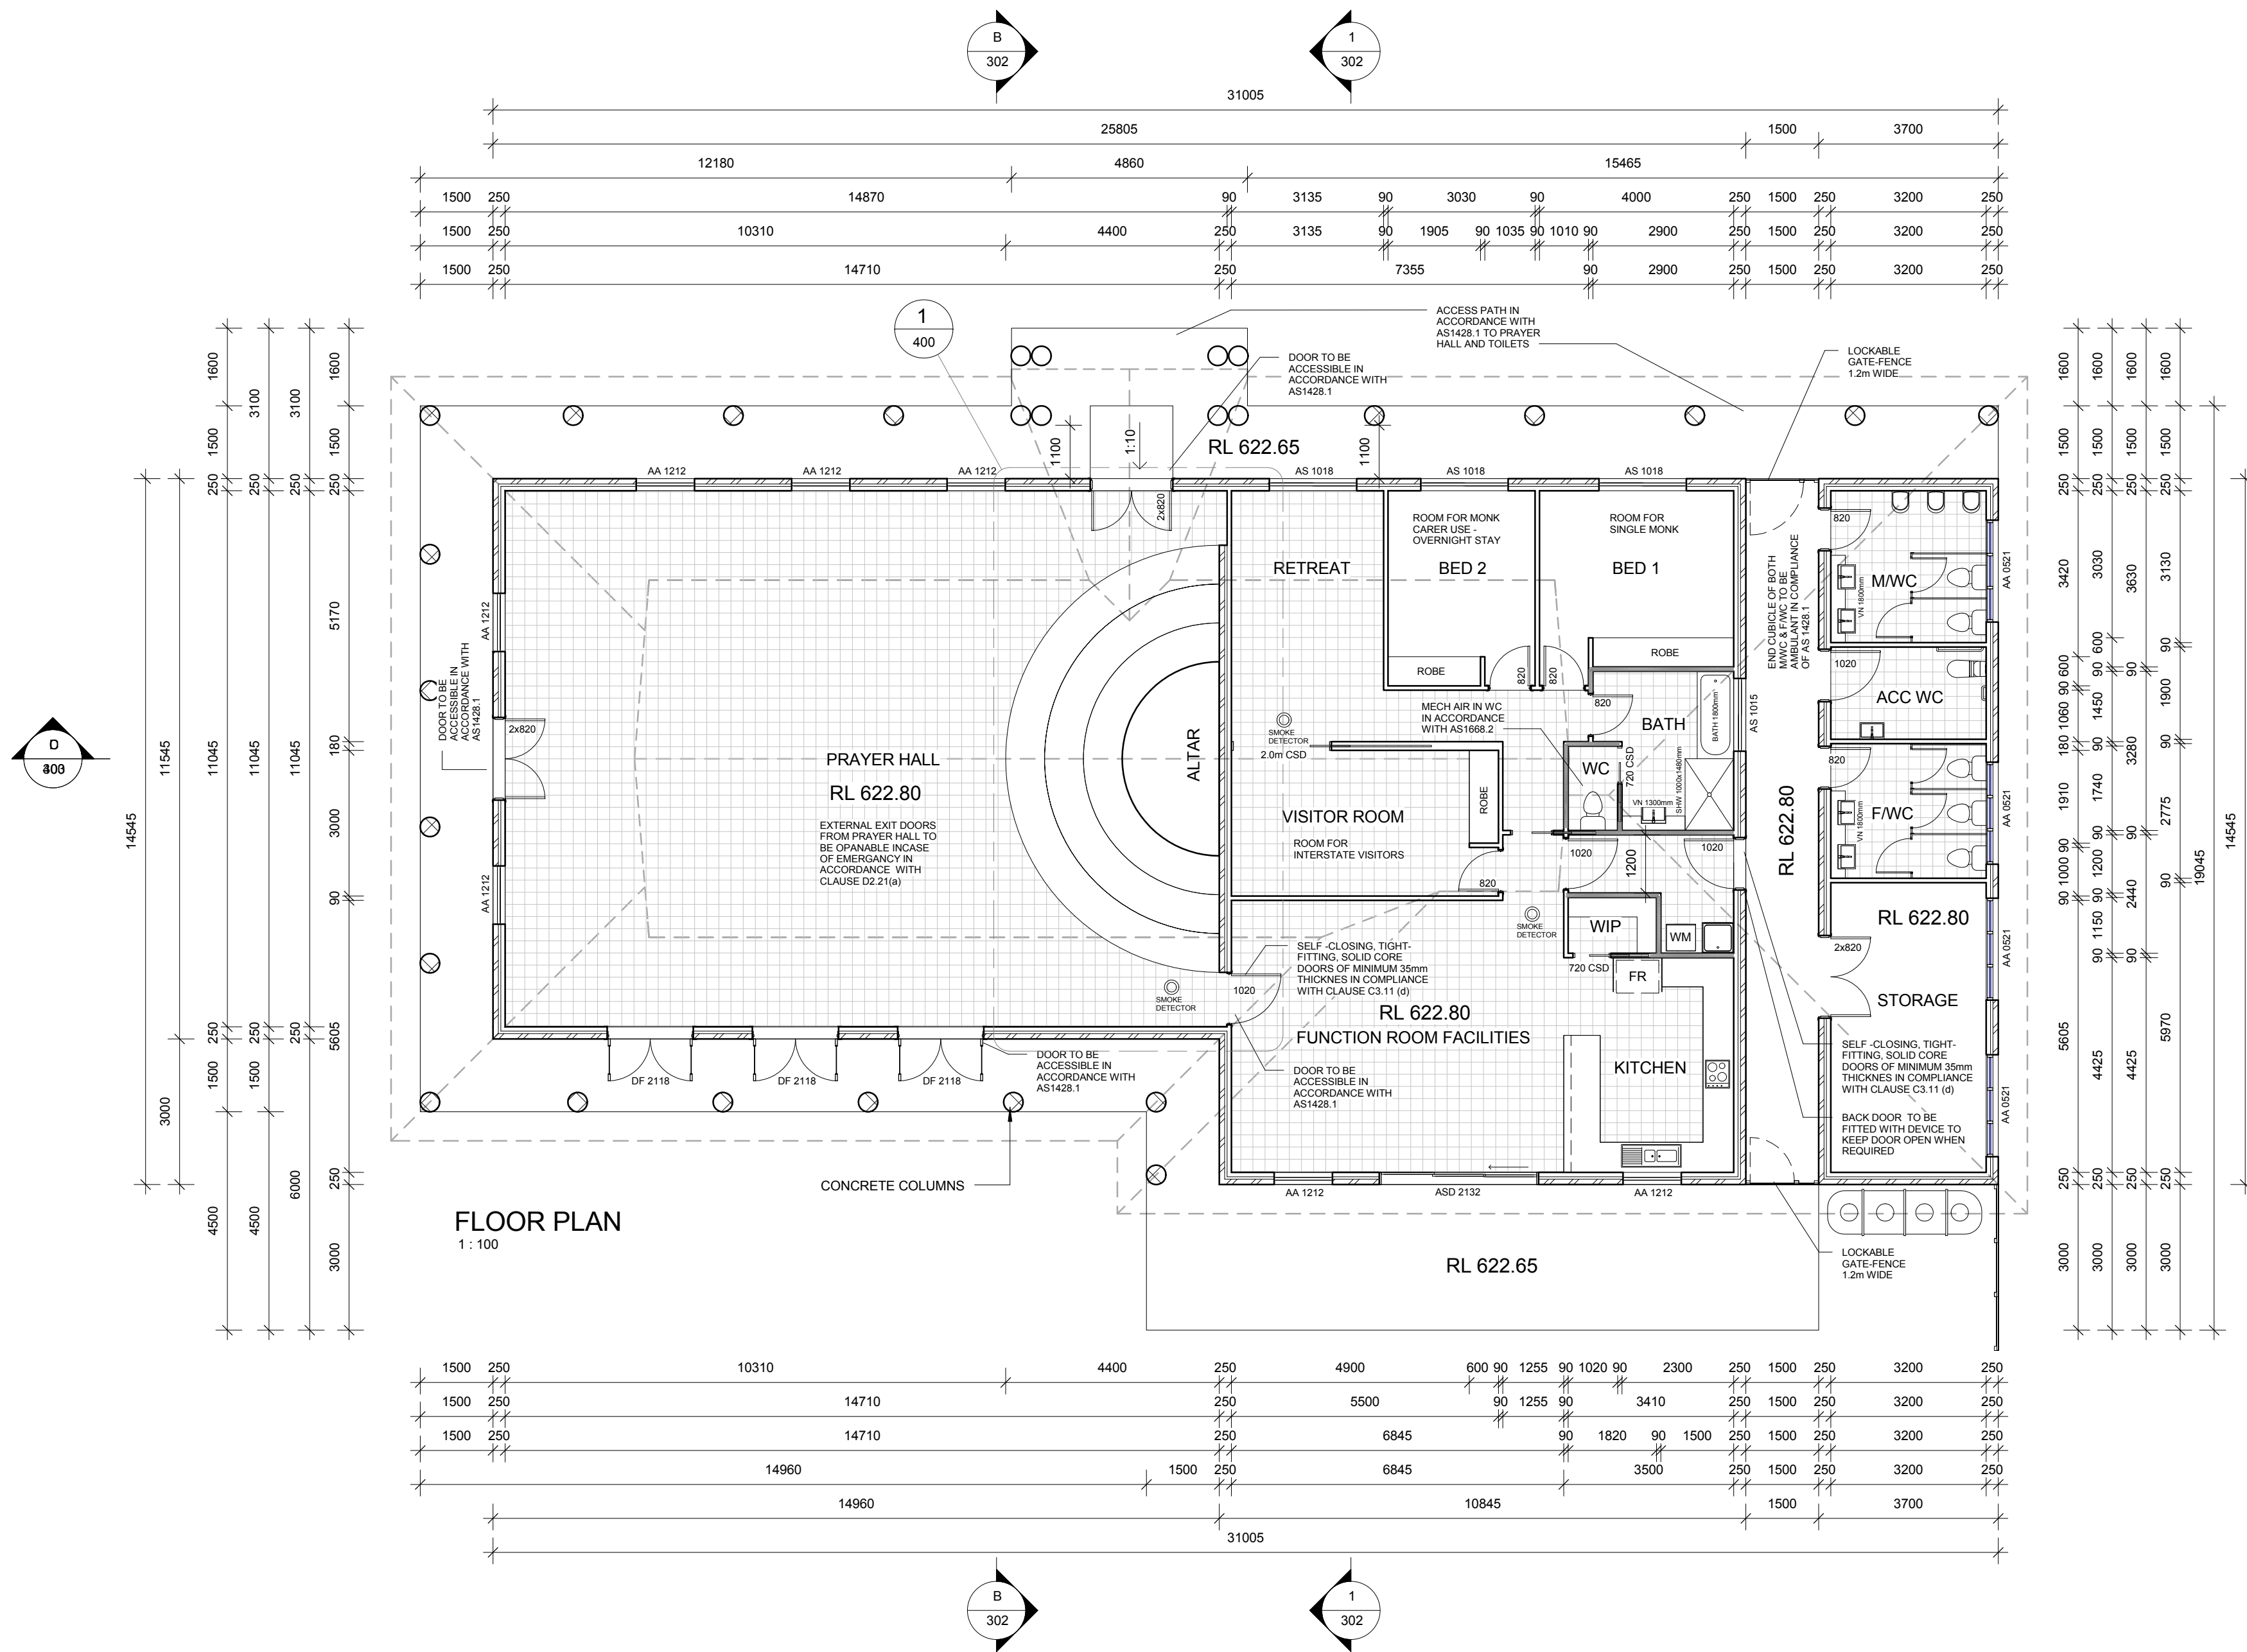

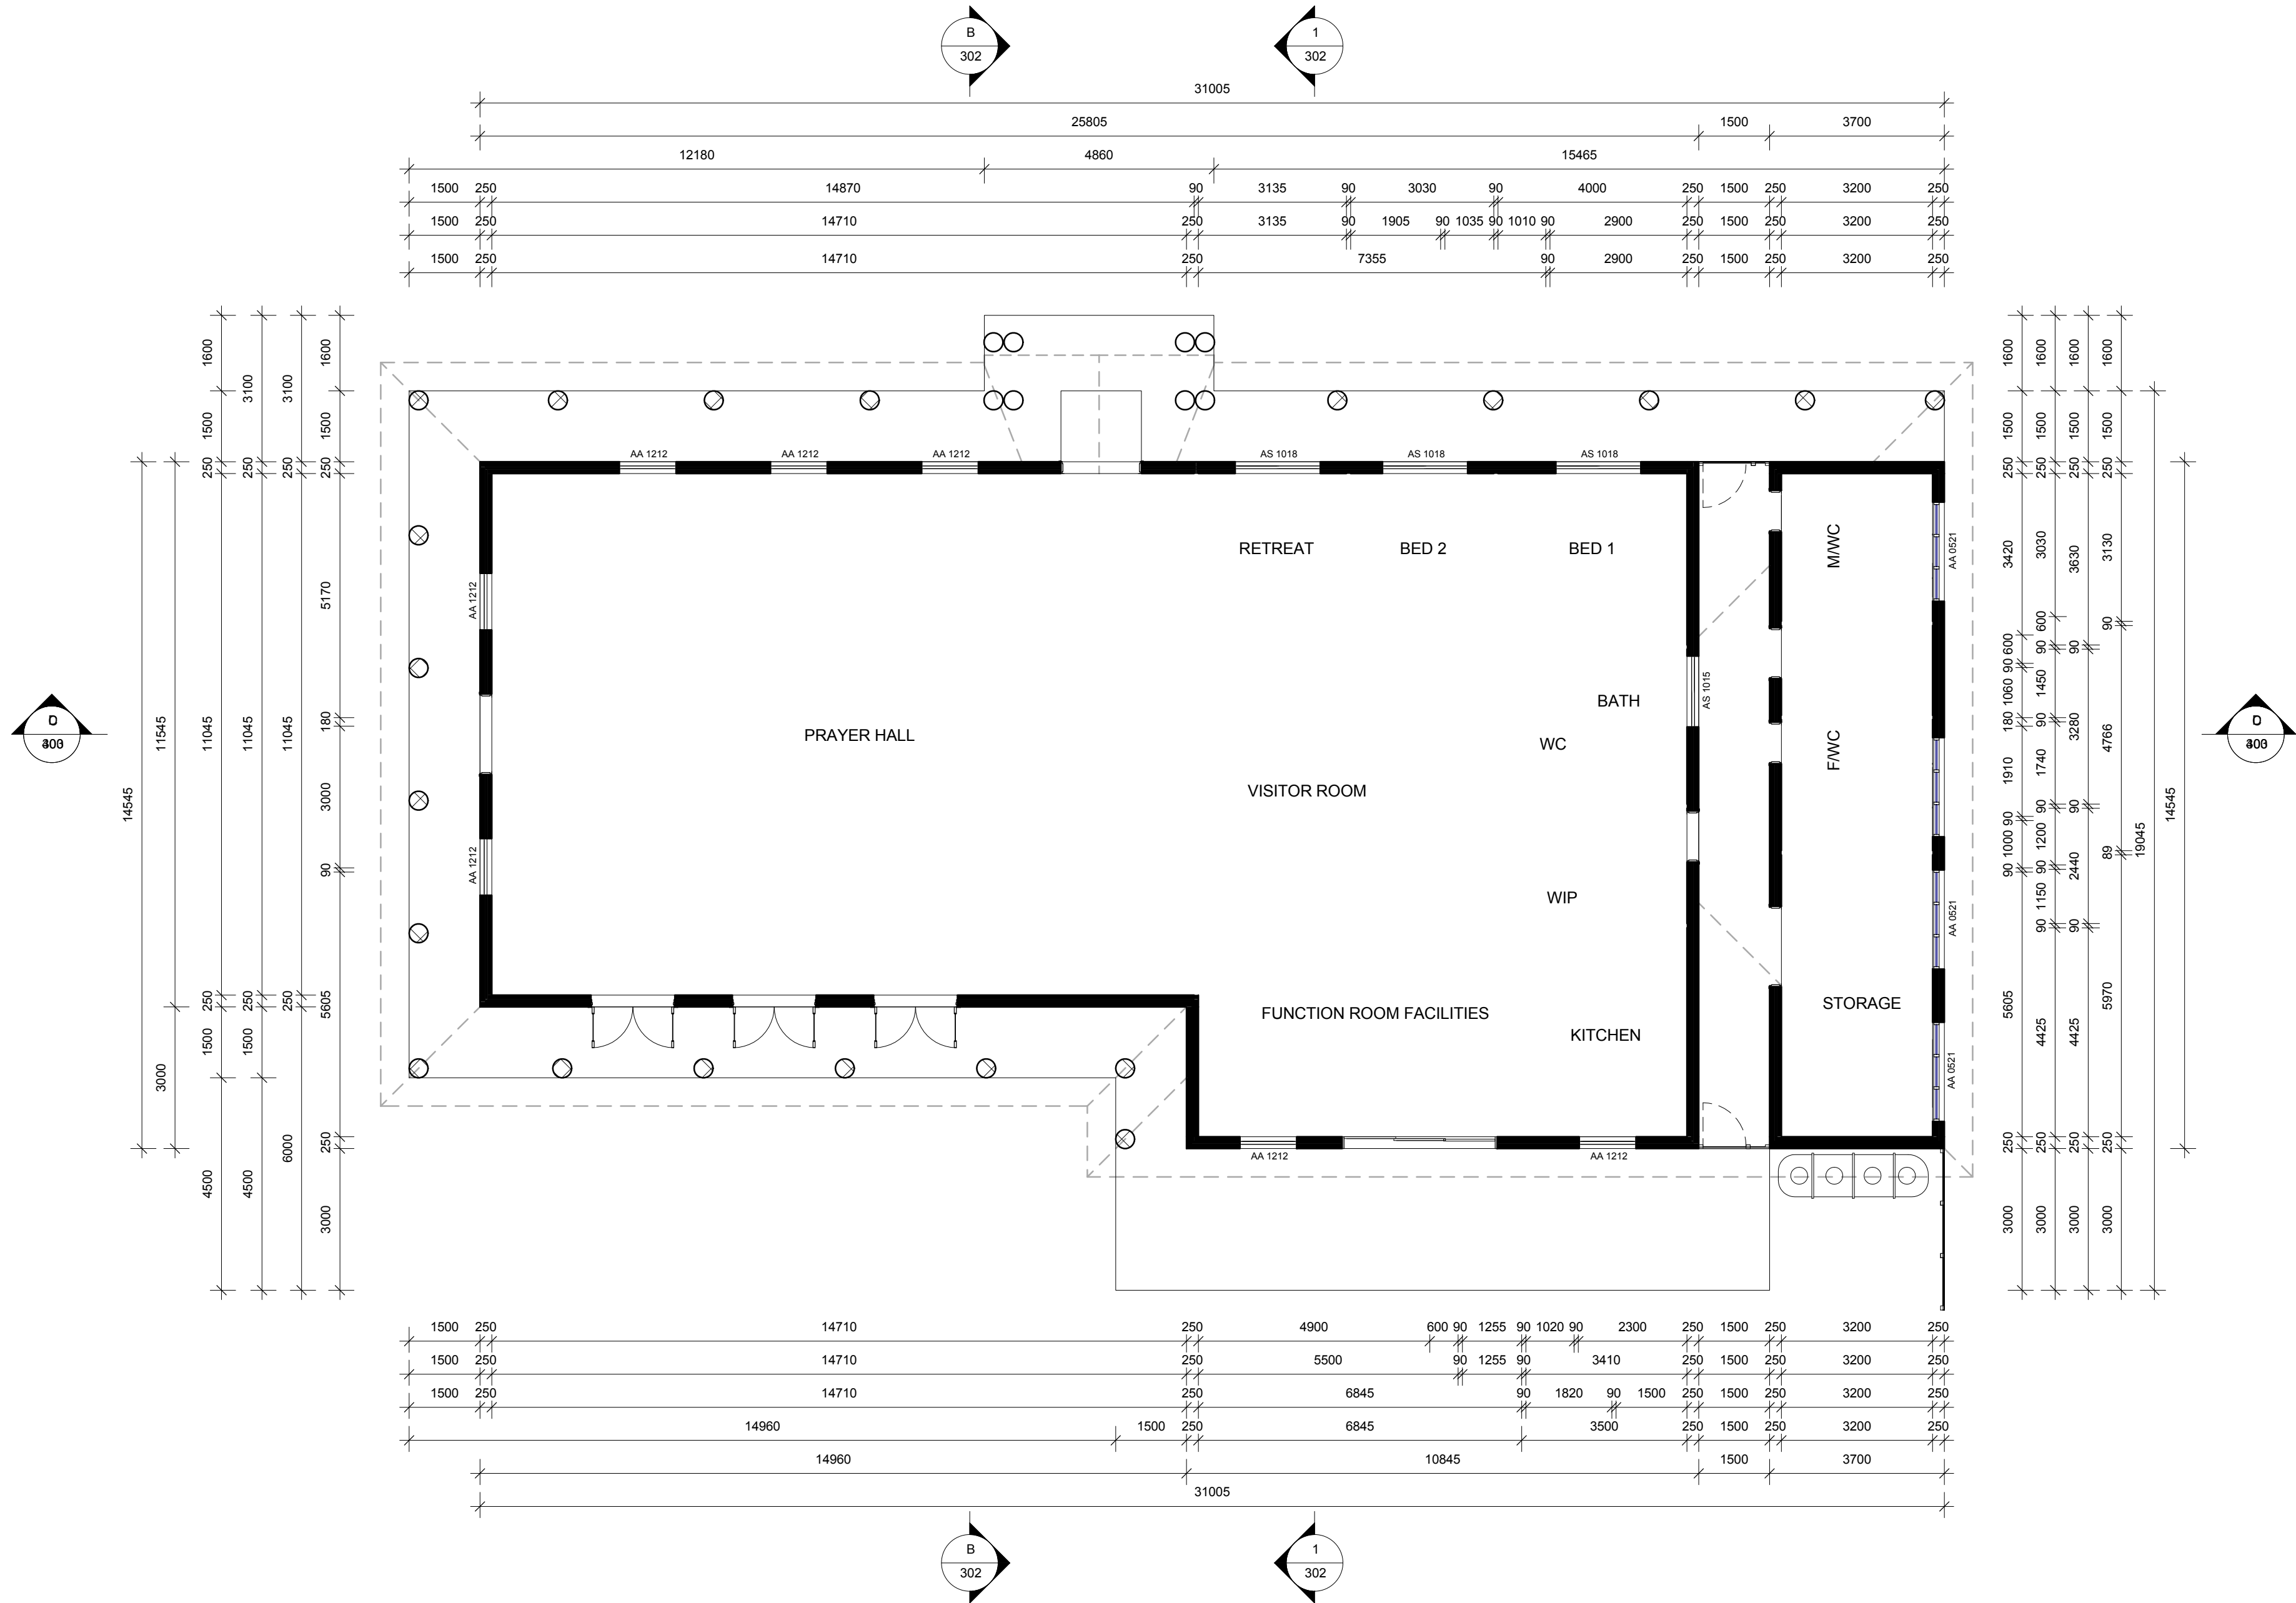

Building Design, Drafting, Architectural  
illustrations, BASIX & Energy Ratings  
ABN: 85441177997  
cristian@studio56.com.au  
0403 363 841  
renee@studio56.com.au  
0402 988 379

© COPYRIGHT Studio56  
THIS PLAN REMAINS THE PROPERTY  
OF Studio56 & MAY NOT BE COPIED IN  
WHOLE OR IN PART WITHOUT  
WRITTEN PERMISSION, FAILURE TO DO  
SO WILL RESULT IN LEGAL ACTION

Client Name: KHEMARARANGSI BUDDHIST TEMPLE OF ACT Inc  
Project : PROPOSED BUDDHIST TEMPLE  
Address: BLOCK 28 SECTION 43 SCULLIN


Sheet Name PUBLIC NOTIFICATION PLAN

Project number 4017-B DA: 201527708  
Date 12.08.2015  
Drawn by B.LAW Design by C.GONZALEZ

Scale 1 : 100

Sheet Number 201


Rev No

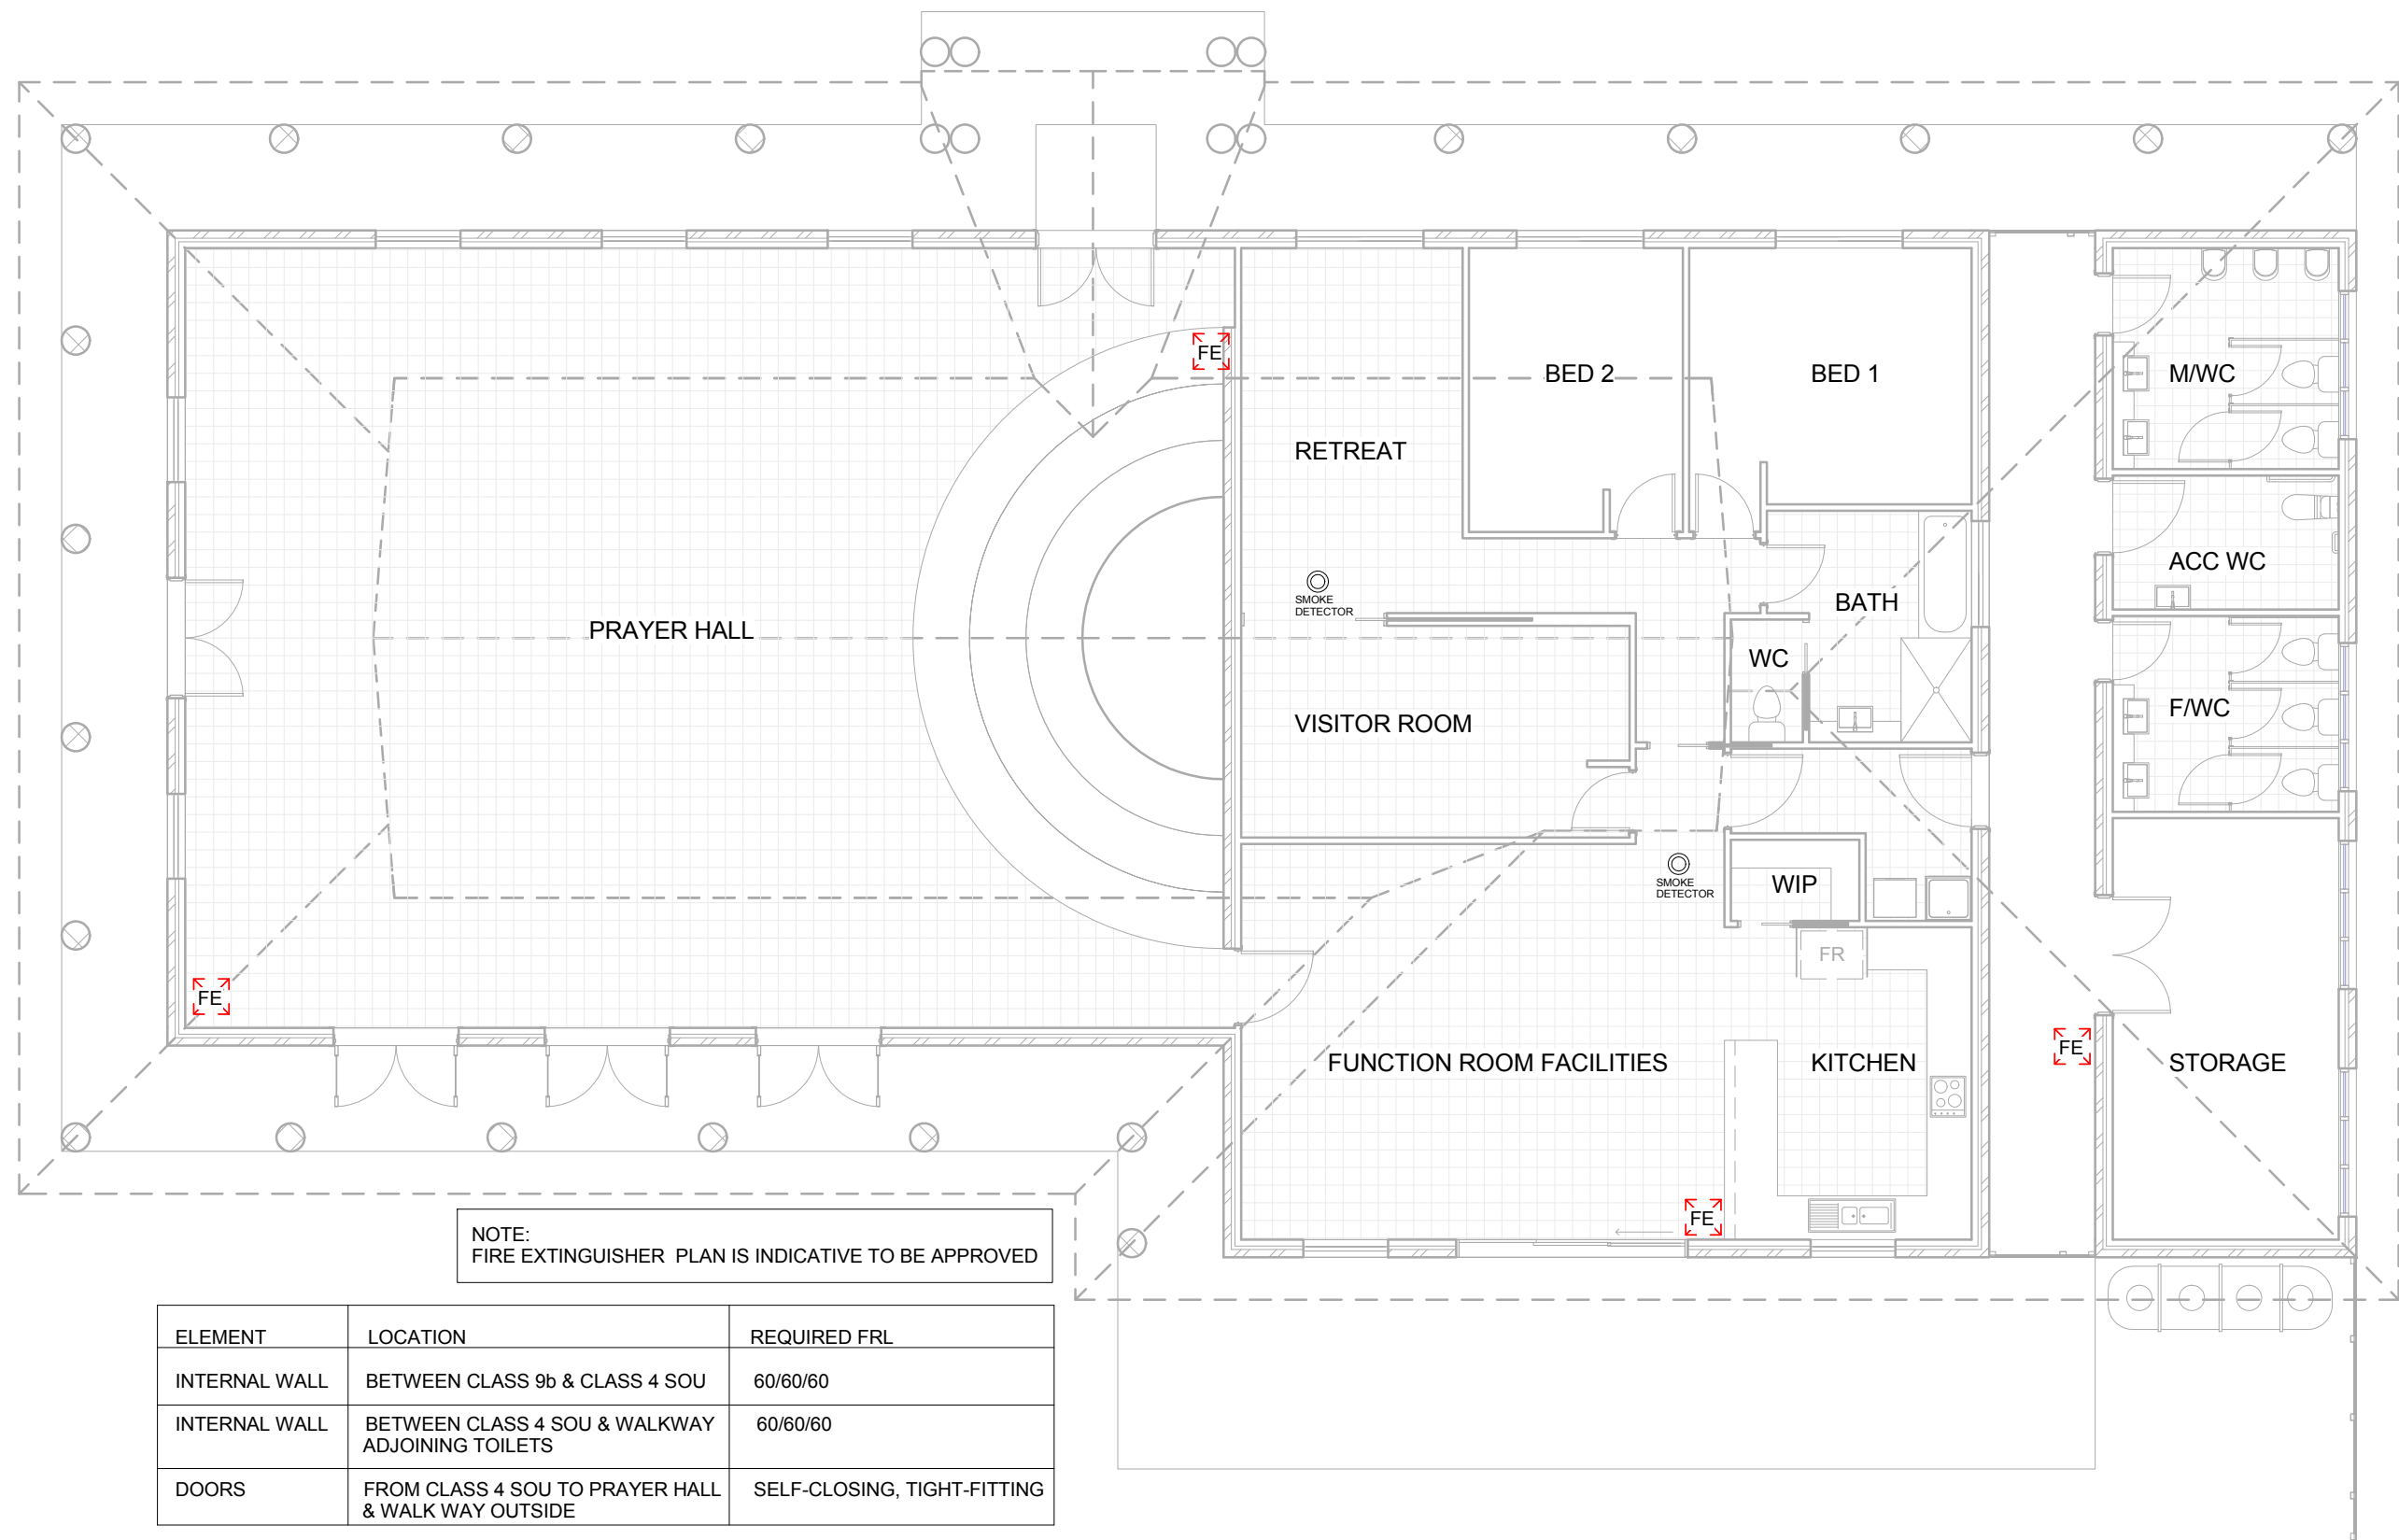


INDICATIVE FIRE PREPARATION PLAN  
1 : 100







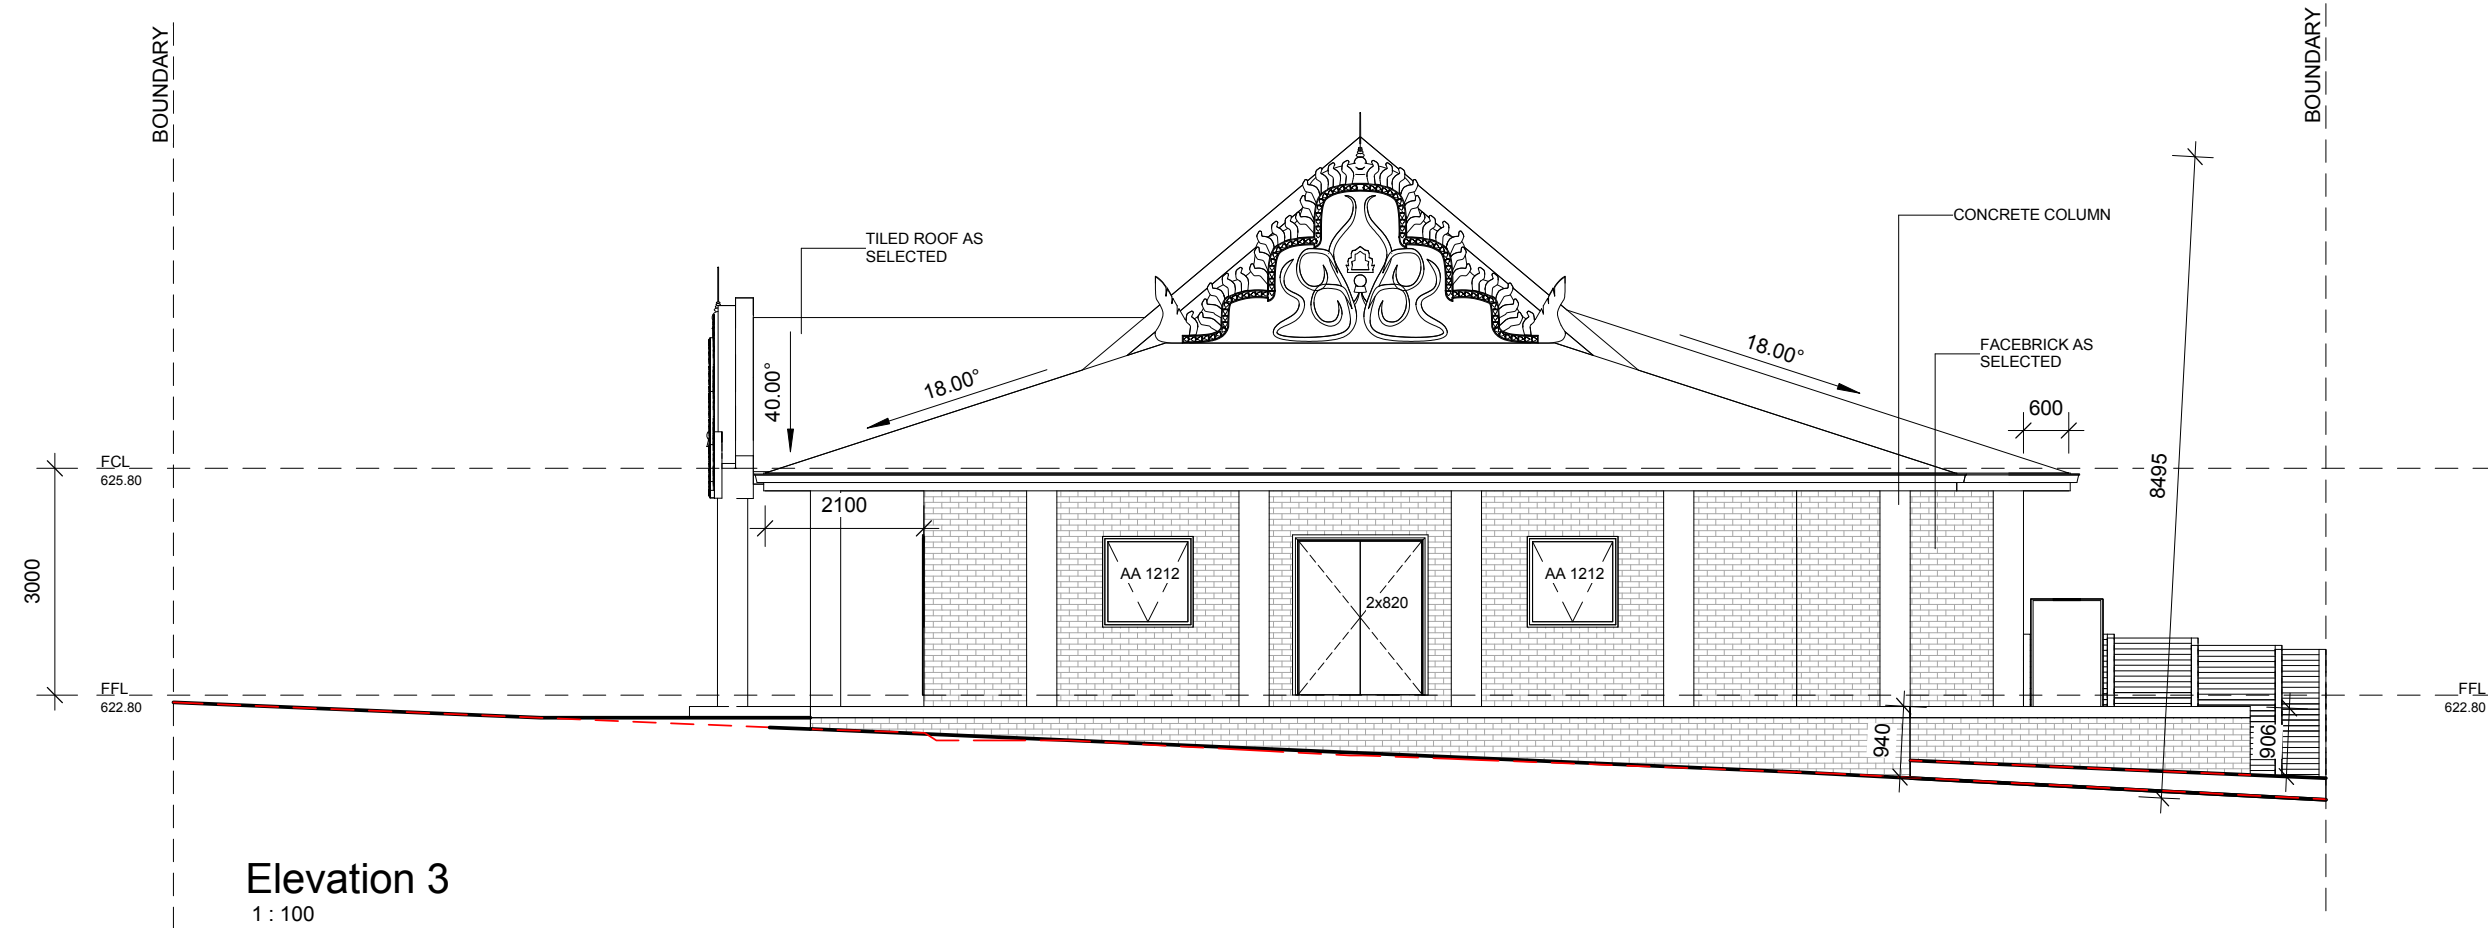


Elevation 3  
1:100

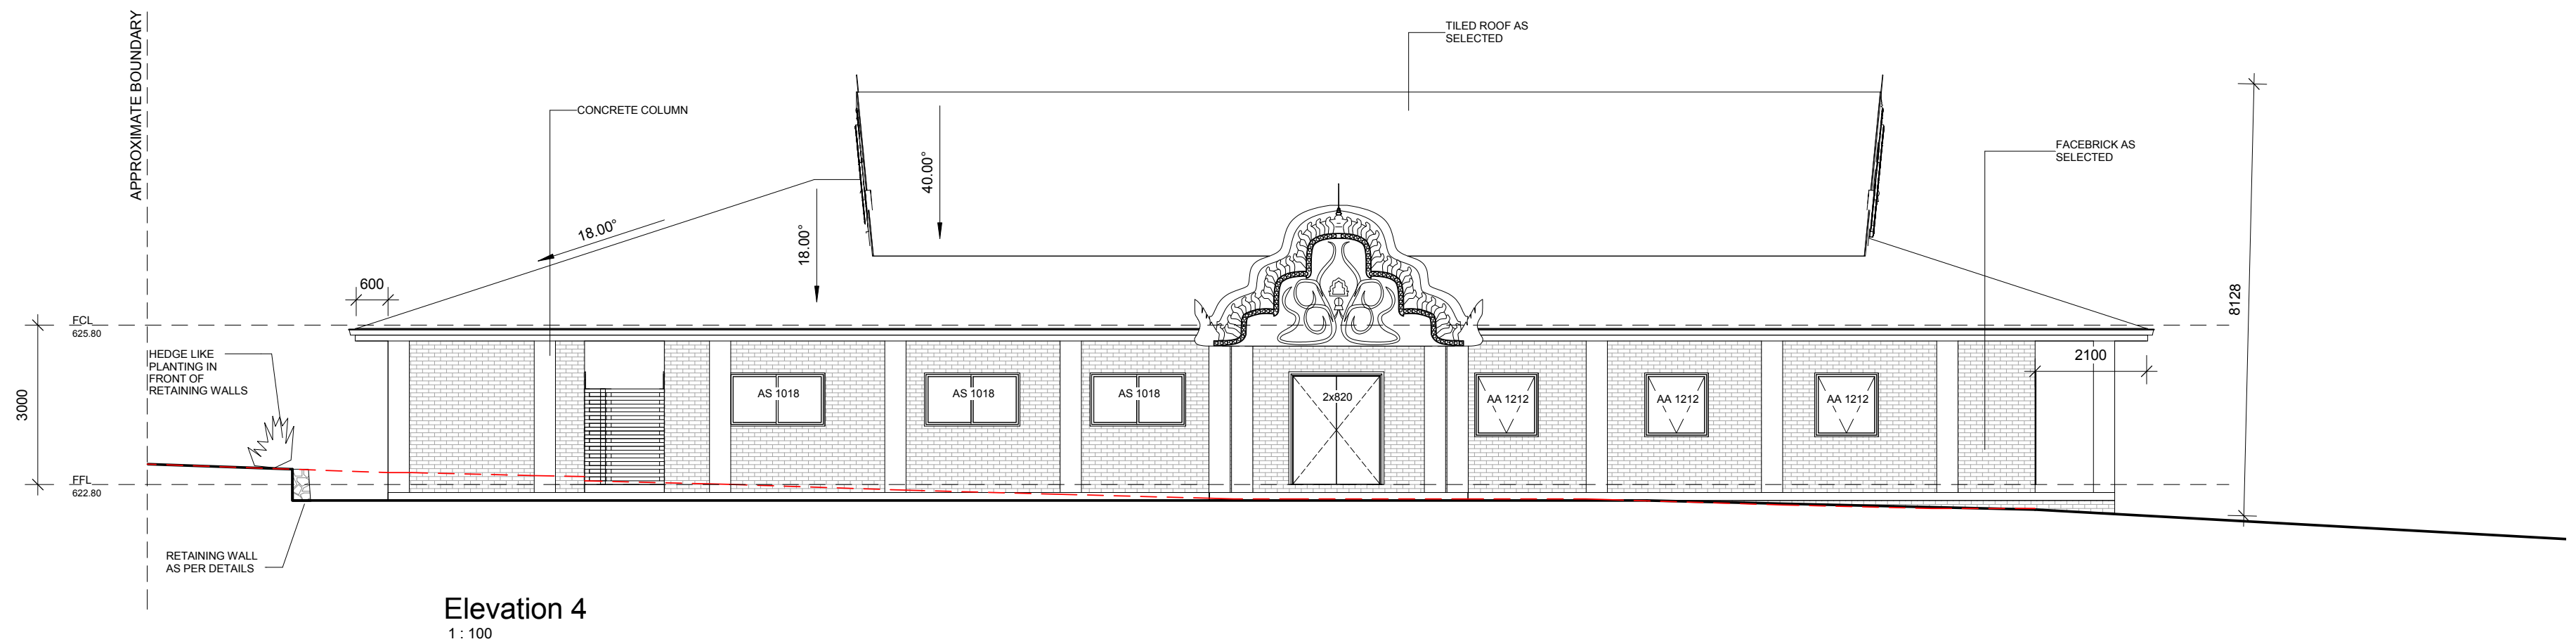




Elevation 4  
1:100

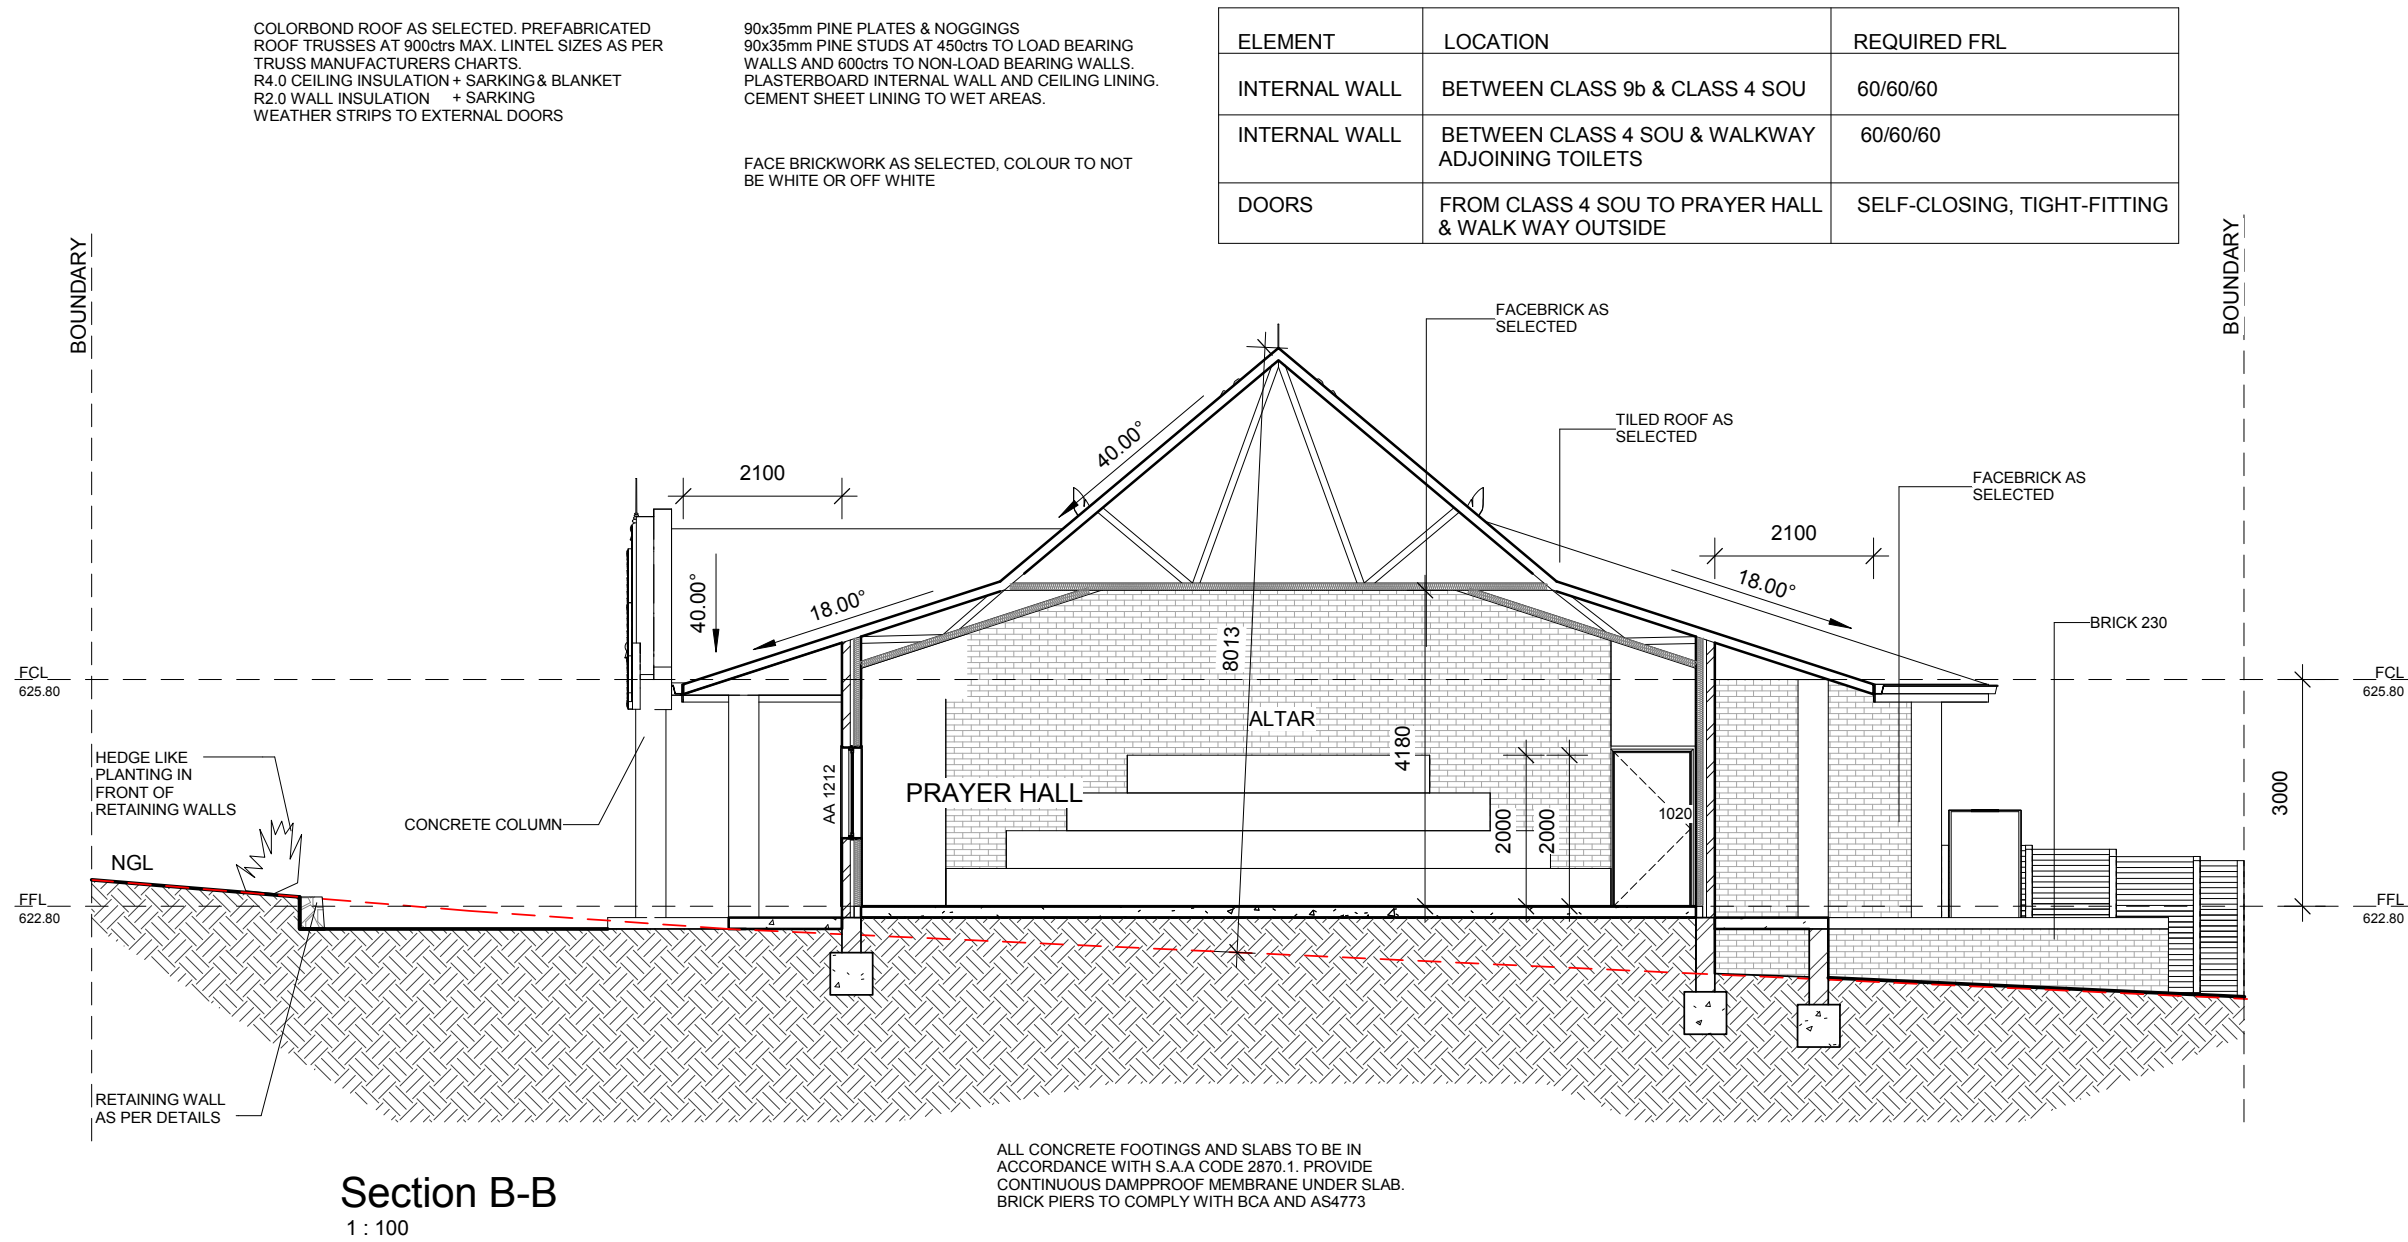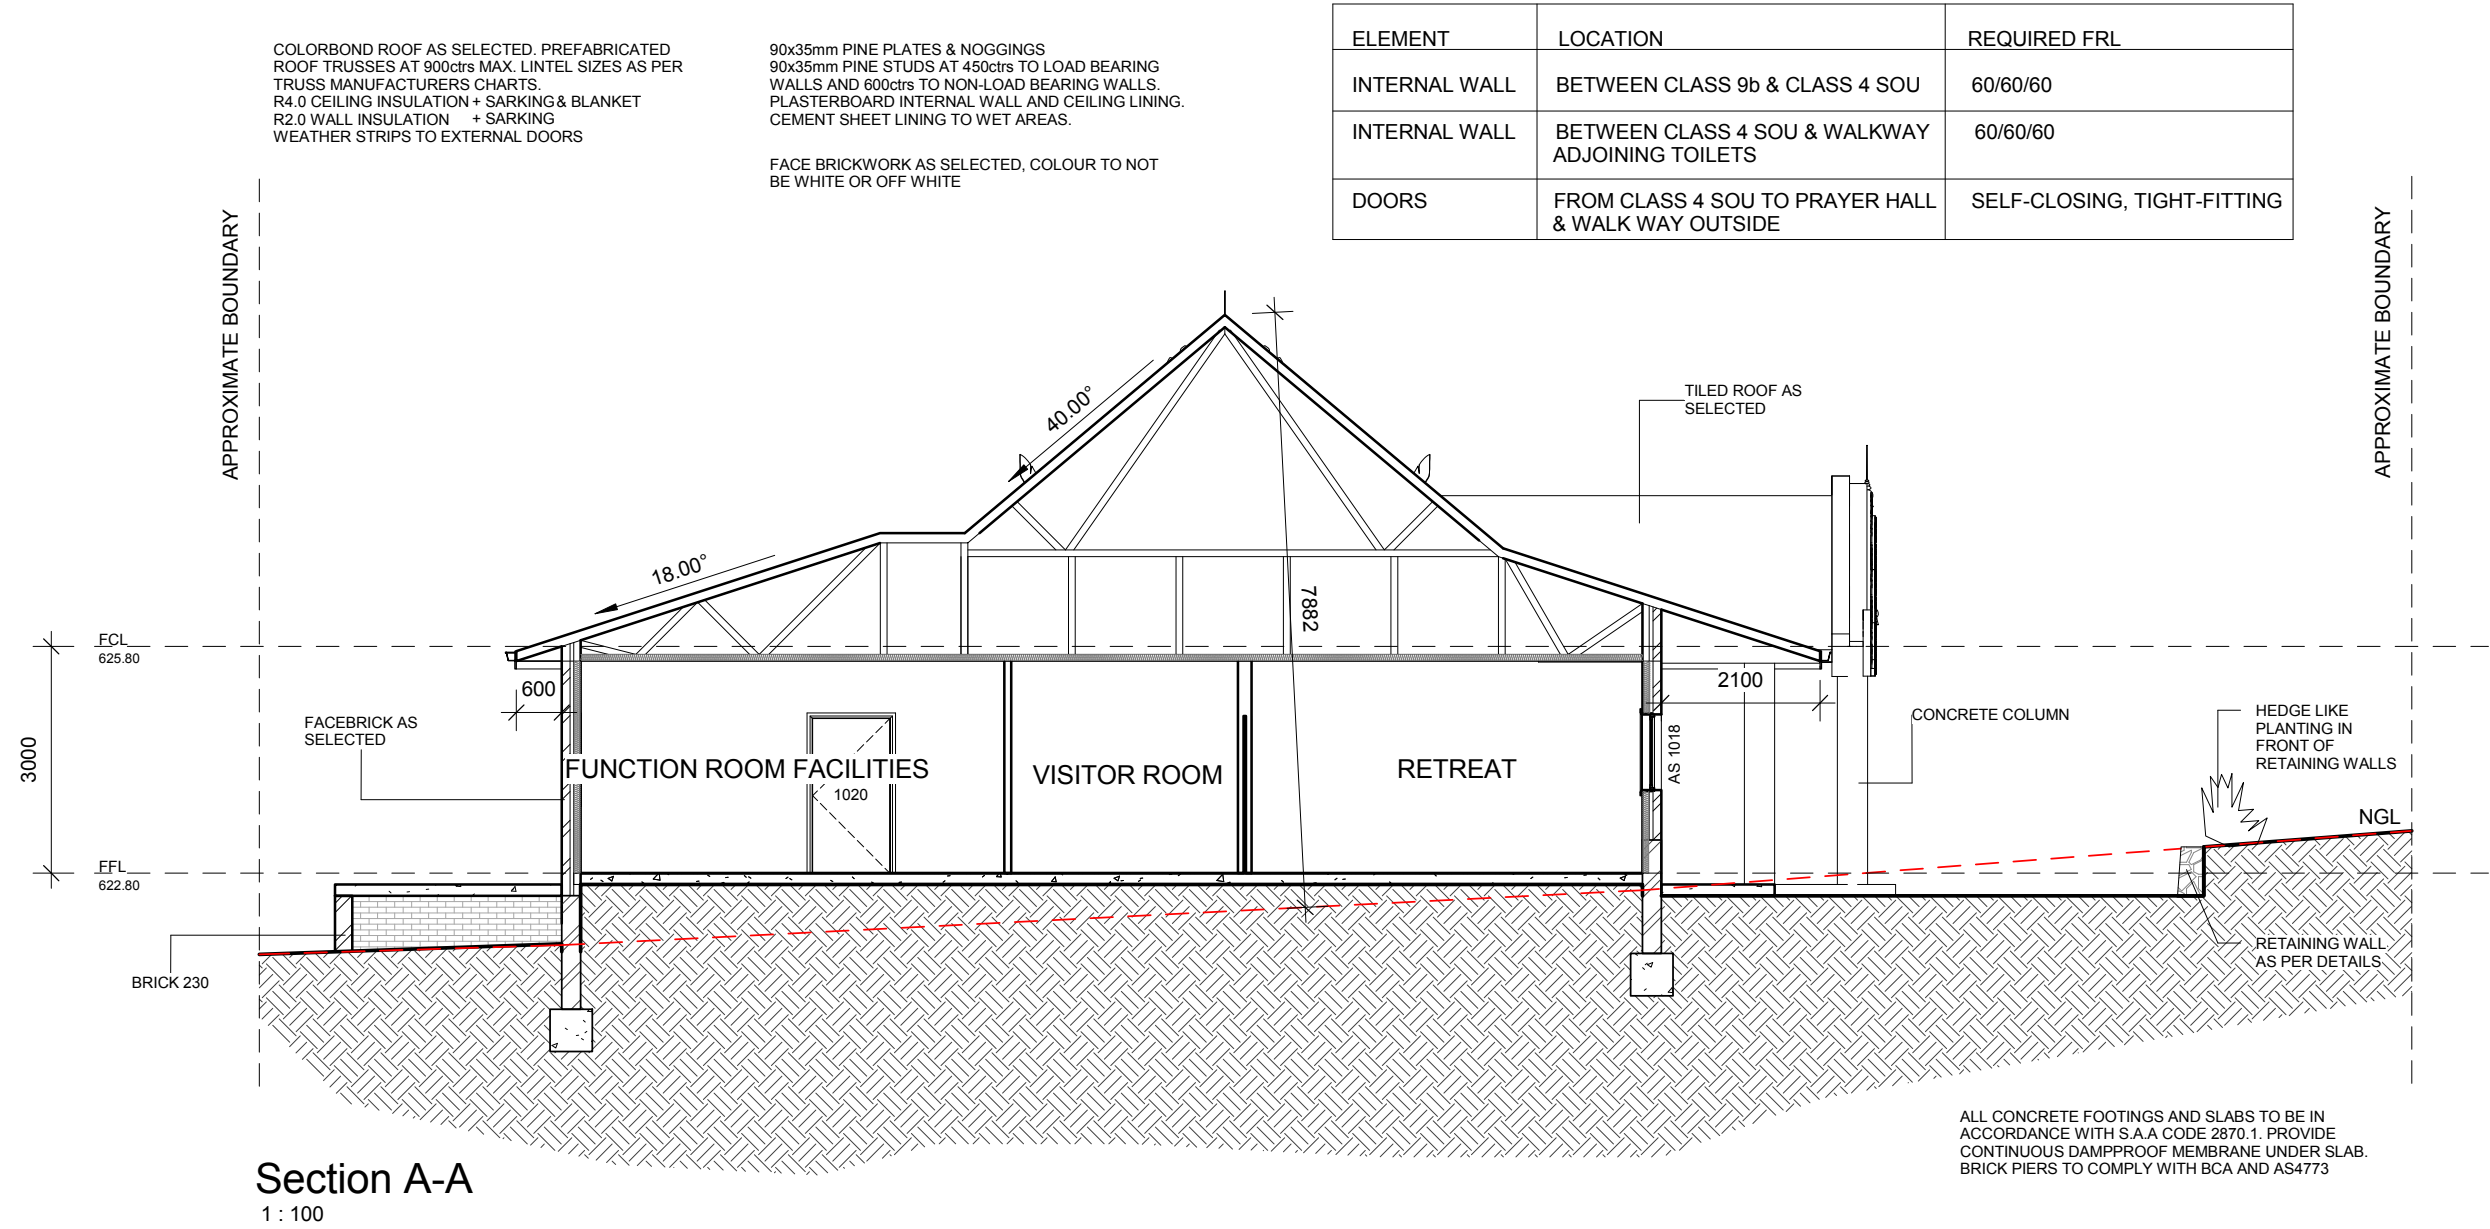

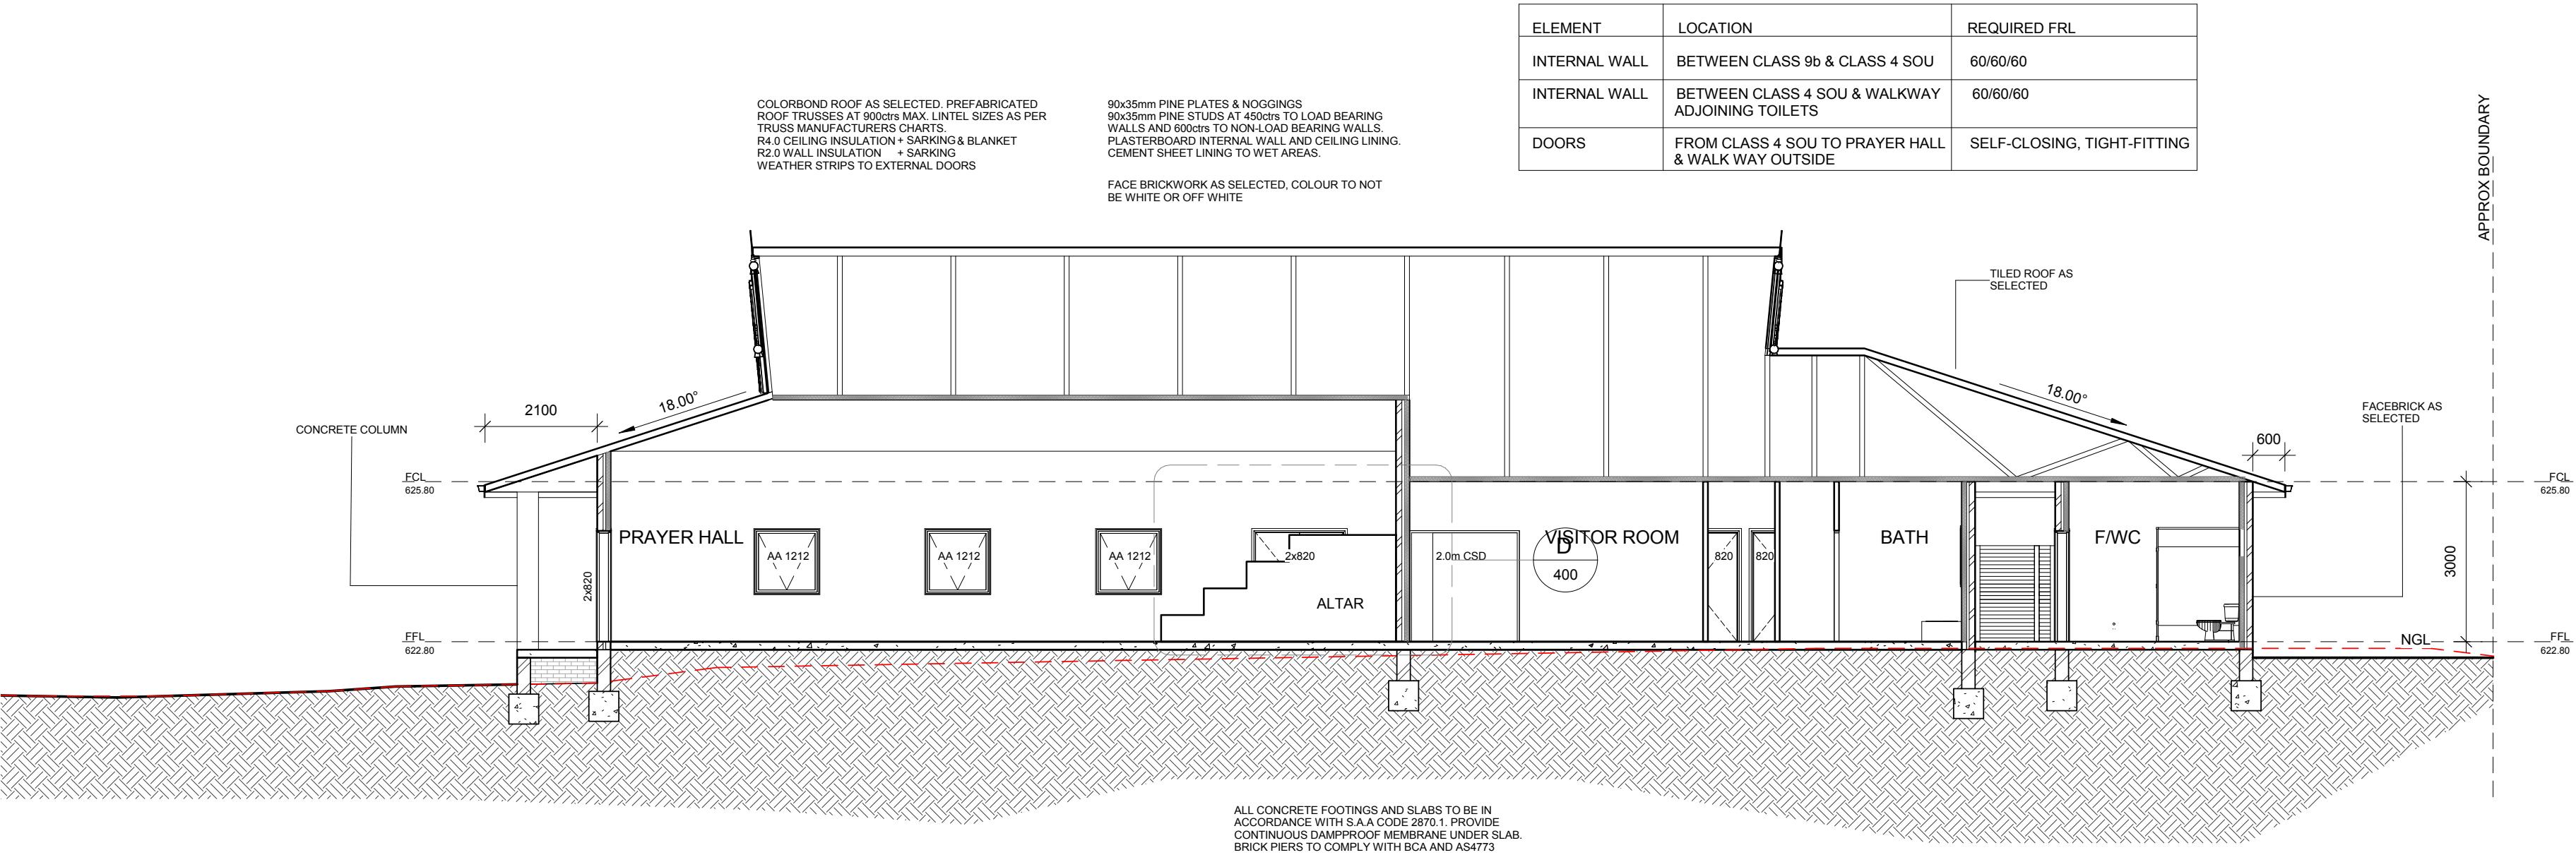


Section C-C  
1 : 100



 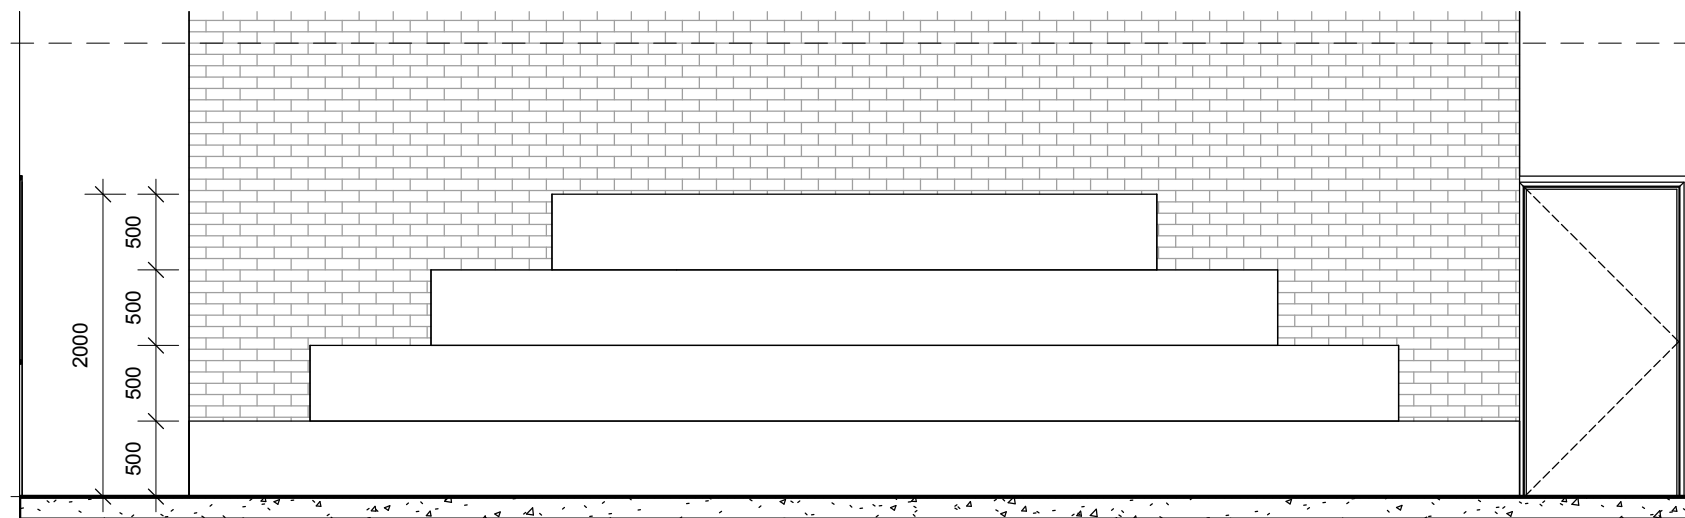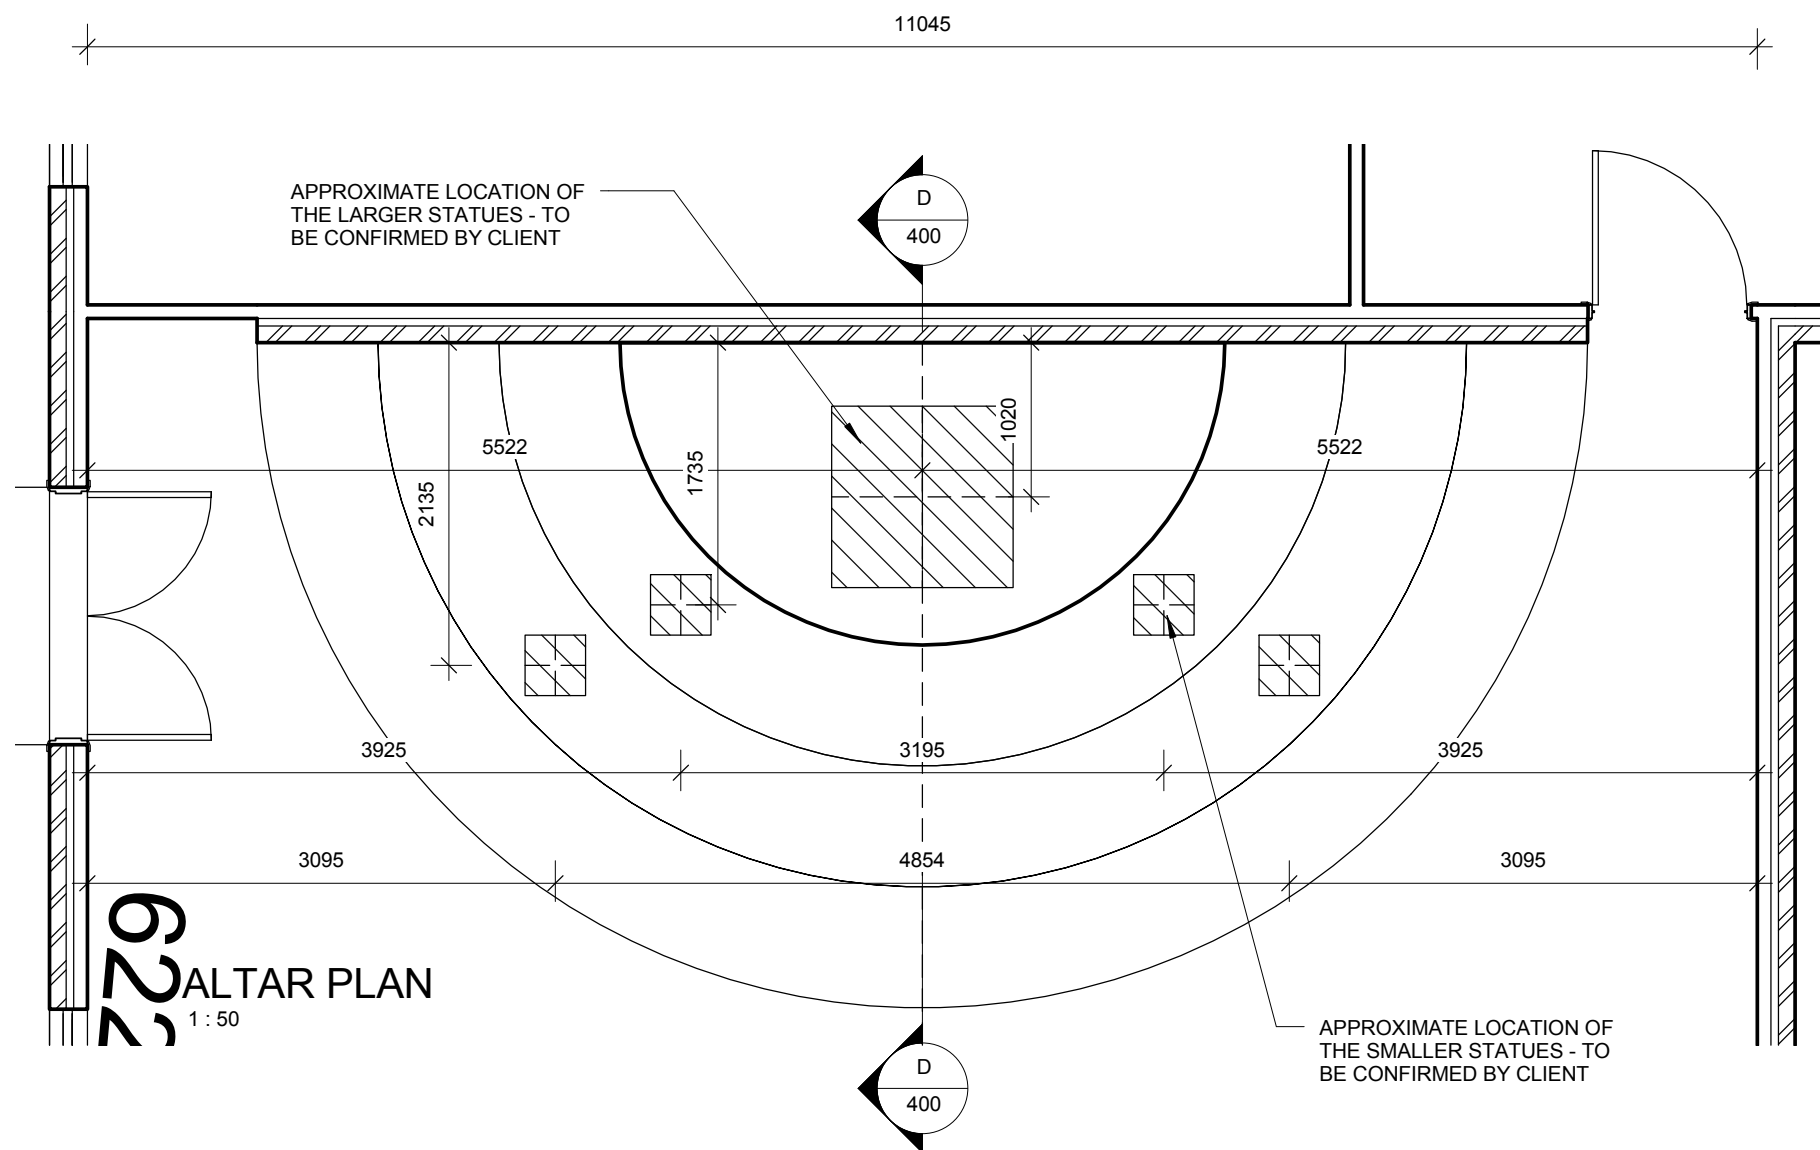

Altar Elevation  
1 : 50

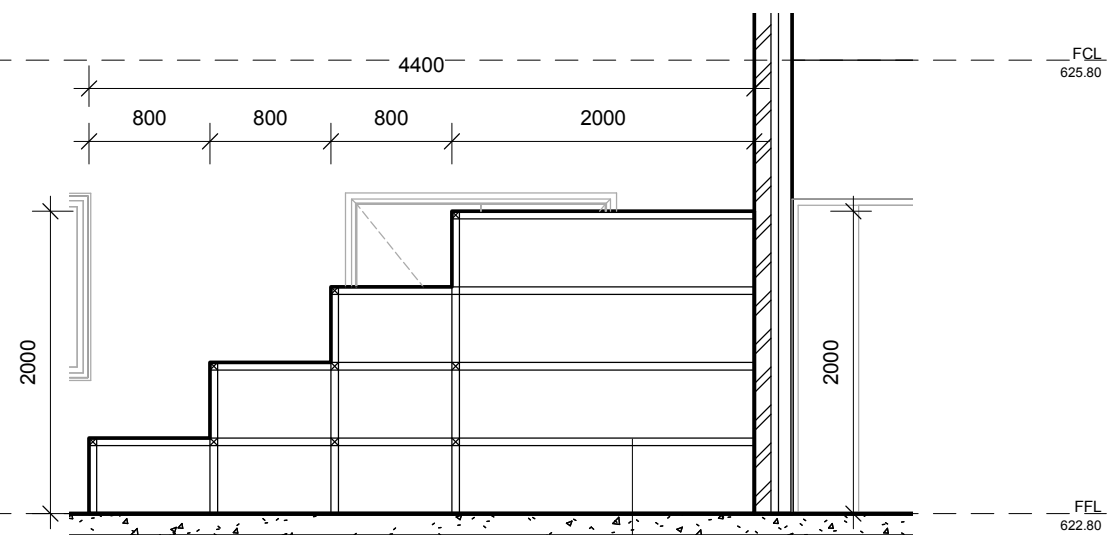

Section D-D  
1 : 50

INDICATIVE STRUCTURAL SUPPORT  
- TO SUSTAIN 2 TONNES OF WEIGHT  
ALL STRUCTURAL INFORMATION & REQUIREMENTS  
TO BE OBTAINED FROM SUITABLY QUALIFIED  
PERSONS - STUDIO56 BUILDING DESIGN IS ONLY  
PROVIDING ARCHITECTURAL DESIGN INFO



Building Design, Drafting, Architectural  
Illustrations, BASIX & Energy Ratings  
ABN: 85441177997  
cristian@studio56.com.au  
0403 363 841  
renee@studio56.com.au  
0402 988 379

© COPYRIGHT Studio56 Building Design  
THIS PLAN REMAINS THE PROPERTY  
OF Studio56 & MAY NOT BE COPIED IN  
WHOLE OR IN PART WITHOUT  
WRITTEN PERMISSION, FAILURE TO DO  
SO WILL RESULT IN LEGAL ACTION

Client Name: KHEMARARANGSI BUDDHIST TEMPLE OF ACT Inc  
Project : PROPOSED BUDDHIST TEMPLE  
Address: BLOCK 28 SECTION 43 SCULLIN

Sheet Name ALTAR DETAILS

Project number	4017-B	Scale	Sheet Number	Rev No
Date	03.08.15	1 : 50	400	
Design by: C.GONZALEZ	Drawn by: C.GONZALEZ			

